


WORKING DRAWINGS FOR EVENT COMPLEX, QADIRABAD MR.GUL NAWAZ KHAN

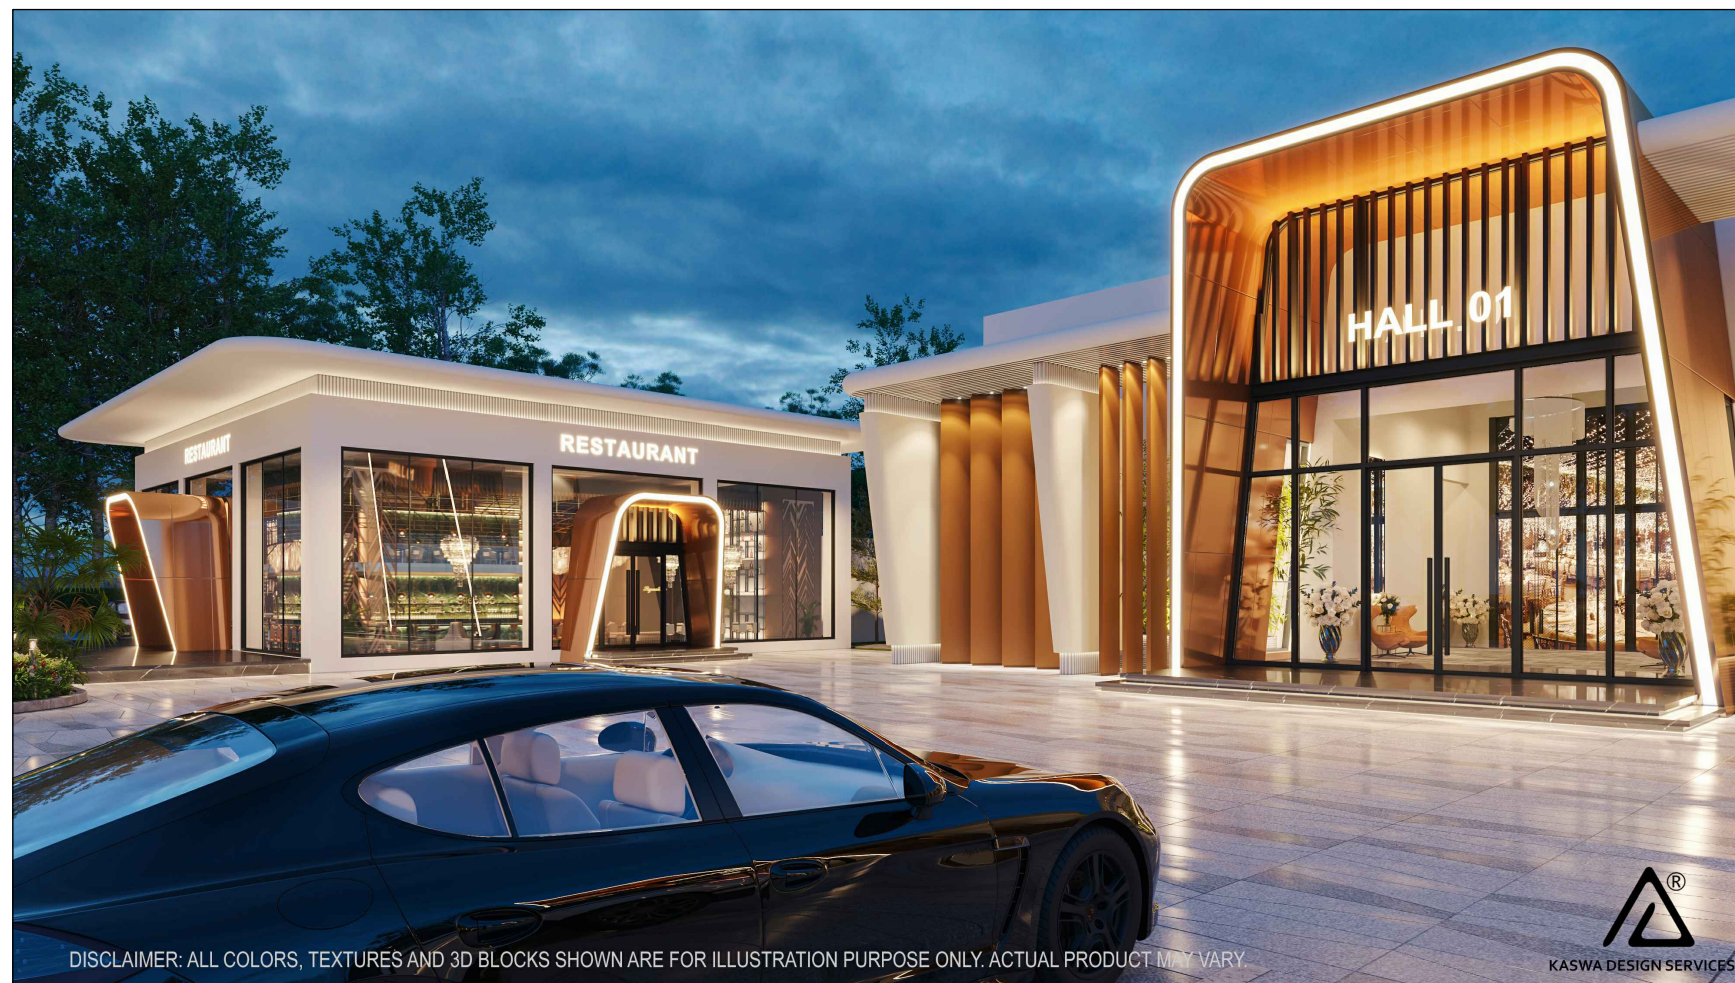

KASWA DESIGN SERVICES
Consulting Architect & Interior Designers
379 TARIQ BLOCK, NEW GARDEN TOWN, LAHORE
042-35858456, 0336-5858450, kaswadesign@gmail.com



LIST OF DRAWINGS

NO:		DRG.NO:	DRAWINGS SET		STRUCTURE DRAWINGS		
01	AD-000	LIST OF DRAWINGS			62	G-01	GENERAL NOTES & SPECIFICATION
02	3D-001	3D VIEWS			63	G-02	STANDARD HOOK DETAILS
03	3D-002	3D VIEWS			64	S-01	FOUNDATION LAYOUT PLAN
04	3D-003	3D VIEWS			65	S-02	FOUNDATION AND COLUMNS REINFORCEMENT DETAILS
05	3D-004	3D VIEWS			66	S-03	FOUNDATION LAYOUT PLAN
06	AD-001	MARQUEE MASTER LAYOUT PLAN			ELECTRICAL DRAWINGS		
07	AD-002	MARQUEE AREA LAYOUT PLAN			66	E-01	ELECTRICAL LEGEND
08	AD-003	SLAUGHTER AREA LAYOUT PLAN			67	E-02	GENERAL NOTES
09	AD-004	MARQUEE AREA PART-01 LAYOUT PLAN			68	E-03	MASTER PLAN ELECTRICAL
10	AD-005	MARQUEE AREA PART-02 LAYOUT PLAN			69	E-04	HALL ELECTRICAL PLAN
11	AD-006	MARQUEE AREA PART-03 LAYOUT PLAN			70	E-05	RESTAURANT ELECTRICAL PLAN
12	AD-007	MARQUEE AREA PART-04 LAYOUT PLAN			71	E-05	ELECTRICAL LAYOUTS PART 1 OF 13
13	AD-008	MARQUEE AREA PART-05 LAYOUT PLAN			72	E-06	ELECTRICAL LAYOUTS PART 2 OF 13
14	AD-009	MARQUEE AREA PART-06 LAYOUT PLAN			73	E-07	ELECTRICAL LAYOUTS PART 3 OF 13
15	AD-010	RESTAURANT AREA PART-01 LAYOUT PLAN			74	E-08	ELECTRICAL LAYOUTS PART 4 OF 13
16	AD-011	RESTAURANT AREA PART-02 LAYOUT PLAN			75	E-09	ELECTRICAL LAYOUTS PART 5 OF 13
17	AD-012	MARQUEE MASTER WORKING LAYOUT PLAN			76	E-10	ELECTRICAL LAYOUTS PART 6 OF 13
18	AD-013	MARQUEE AREA WORKING LAYOUT PLAN			77	E-11	ELECTRICAL LAYOUTS PART 7 OF 13
19	AD-014	SLAUGHTER AREA WORKING LAYOUT PLAN			78	E-12	ELECTRICAL LAYOUTS PART 8 OF 13
20	AD-015	MARQUEE AREA PART-01 WORKING LAYOUT PLAN			79	E-13	ELECTRICAL LAYOUTS PART 9 OF 13
21	AD-016	MARQUEE AREA PART-02 WORKING LAYOUT PLAN			80	E-14	ELECTRICAL LAYOUTS PART 10 OF 13
22	AD-017	MARQUEE AREA PART-03 WORKING LAYOUT PLAN			81	E-15	ELECTRICAL LAYOUTS PART 11 OF 13
23	AD-018	MARQUEE AREA PART-04 WORKING LAYOUT PLAN			82	E-05	ELECTRICAL LAYOUTS PART 12 OF 13
24	AD-019	MARQUEE AREA PART-05 WORKING LAYOUT PLAN			PUBLIC HEALTH DRAWINGS		
25	AD-020	MARQUEE AREA PART-06 WORKING LAYOUT PLAN			83	PH-01	DRAINAGE MASTER LAYOUTS
26	AD-021	MARQUEE AREA 1ST FLOOR WORKING LAYOUT PLAN			84	PH-02	DRAINAGE LAYOUTS PART 1 OF 13
27	AD-022	RESTAURANT AREA PART-01 WORKING LAYOUT PLAN			85	PH-03	DRAINAGE LAYOUTS PART 2 OF 13
28	AD-023	RESTAURANT AREA PART-02 WORKING LAYOUT PLAN			86	PH-04	DRAINAGE LAYOUTS PART 3 OF 13
29	AD-024	MAIN BUILDING FRONT ELEVATION			87	PH-04	DRAINAGE LAYOUTS PART 4 OF 13
30	AD-025	MAIN BUILDING FRONT ELEVATION BLOWUP PART-01 & 02			88	PH-05	DRAINAGE LAYOUTS PART 5 OF 13
31	AD-026	MAIN BUILDING FRONT ELEVATION BLOWUP PART-03			89	PH-06	DRAINAGE LAYOUTS PART 6 OF 13
32	AD-027	MAIN BUILDING REAR ELEVATION			90	PH-07	DRAINAGE LAYOUTS PART 7 OF 13
33	AD-028	MAIN BUILDING REAR ELEVATION BLOWUP-01			91	PH-08	DRAINAGE LAYOUTS PART 8 OF 13
34	AD-029	MAIN BUILDING REAR ELEVATION BLOWUP-02			92	PH-09	DRAINAGE LAYOUTS PART 9 OF 13
35	AD-030	MAIN BUILDING REAR ELEVATION BLOWUP-03			93	PH-10	DRAINAGE LAYOUTS PART 10 OF 13
36	AD-031	MAIN BUILDING RIGHT SIDE ELEVATION			94	PH-11	DRAINAGE LAYOUTS PART 11 OF 13
37	AD-032	MAIN BUILDING RIGHT SIDE ELEVATION BLOWUP-01			95	PH-12	DRAINAGE LAYOUTS PART 12 OF 13
38	AD-033	MAIN BUILDING RIGHT SIDE ELEVATION BLOWUP-02			96	PH-13	DRAINAGE LAYOUTS PART 13 OF 13
39	AD-034	MAIN BUILDING LEFT SIDE ELEVATION			97	PH-14	WATER SUPPLY GROUND FLOOR MASTER LAYOUT
40	AD-035	MAIN BUILDING LEFT SIDE ELEVATION BLOWUP-01			98	PH-15	WATER SUPPLY ROOF MASTER LAYOUT
41	AD-036	MAIN BUILDING LEFT SIDE ELEVATION BLOWUP-02			99	PH-16	DRAINAGE LAYOUTS PART 1 OF 13
42	AD-037	MAIN BUILDING SECTION			100	PH-17	WATER SUPPLY LAYOUTS PART 2 OF 13
43	AD-038	MAIN BUILDING SECTION BLOWUP-01			101	PH-18	WATER SUPPLY LAYOUTS PART 3 OF 13
44	AD-039	MAIN BUILDING SECTION BLOWUP-02			102	PH-19	WATER SUPPLY LAYOUTS PART 4 OF 13
45	AD-040	RESTAURANT FRONT ELEVATION			103	PH-20	WATER SUPPLY LAYOUTS PART 5 OF 13
46	AD-041	RESTAURANT SECTION-AA			104	PH-21	WATER SUPPLY LAYOUTS PART 6 OF 13
47	AD-042	RESTAURANT SECTION-BB			105	PH-22	WATER SUPPLY LAYOUTS PART 7 OF 13
48	AD-043	MAIN GATE WITH FRONT BOUNDARY WALL MASTER PLAN & ELEVATION			106	PH-23	WATER SUPPLY LAYOUTS PART 8 OF 13
49	AD-044	MAIN GATE BASE DETAIL			107	PH-24	WATER SUPPLY LAYOUTS PART 9 OF 13
50	AD-045	FRONT BOUNDARY WALL DIVISION PLANS			108	PH-25	WATER SUPPLY LAYOUTS PART 10 OF 13
51	AD-046	MAIN GATE UPPER PLANS DETAIL			109	PH-26	WATER SUPPLY LAYOUTS PART 11 OF 13
52	AD-047	MAIN GATE ELEVATION & SECTION DETAIL			110	PH-27	WATER SUPPLY LAYOUTS PART 12 OF 13
53	AD-048	FRONT BOUNDARY WALL DETAIL-02			111	PH-28	WATER SUPPLY LAYOUTS PART 13 OF 13
54	AD-049	MAIN GATE BLOWUP DETAIL-01			112	PH-29	GAS SUPPLY GROUND FLOOR MASTER LAYOUT
55	AD-050	PLAN BLOWUP DETAIL-01			113	PH-30	GAS SUPPLY LAYOUTS PART 2 OF 11
56	AD-051	SECTION-01 BLOWUP DETAIL-01			114	PH-31	GAS SUPPLY LAYOUTS PART 3 OF 11
57	AD-052	SECTION-02 BLOWUP DETAIL-01			115	PH-32	GAS SUPPLY LAYOUTS PART 4 OF 11
58	AD-053	PLAN BLOWUP DETAIL-02			116	PH-33	GAS SUPPLY LAYOUTS PART 5 OF 11
59	AD-054	ELEVATION BLOWUP DETAIL-02			117	PH-34	GAS SUPPLY LAYOUTS PART 6 OF 11
60	AD-055	SECTION-02 BLOWUP DETAIL-02			118	PH-35	GAS SUPPLY LAYOUTS PART 7 OF 11
61	AD-056	SECTION-02 BLOWUP DETAIL-02			119	PH-36	GAS SUPPLY LAYOUTS PART 8 OF 11
62	AD-057	BLOWUP DETAIL-03			120	PH-37	GAS SUPPLY LAYOUTS PART 9 OF 11
63	AD-058	BLOWUP DETAIL-04			121	PH-38	GAS SUPPLY LAYOUTS PART 10 OF 11
64	AD-059	BLOWUP DETAIL-05			122	PH-39	GAS SUPPLY LAYOUTS PART 11 OF 11
65	AD-060	BLOWUP DETAIL-06					
66	AD-061	BLOWUP DETAIL-07					
67	AD-062	SECTION-08 & 09					



 KASWA DESIGN SERVICES Consulting Architect & Interior Designers 379, TARIQ BLOCK, NEW GARDEN TOWN, LAHORE 042-35858456, 0336-5858450, kaswadesign@gmail.com STRUCTURAL CONSULTANT:				SCALE:		DRAWING TITLE:		PROJECT:		DRAWING NO.:	
				DATE:		WORKING DRAWING		EVENT COMPLEX QADIRABAD		NO.	
				DRAWN BY:		3D VIEWS		FOR		DATE	
				CHECKED BY:		LOCATION		MR.GUL NAWAZ KHAN		REVISION	
						QADIRABAD		PROJECT CODE:			
				ARCHITECT'S SIGNATURE:							




DRAWING NO.: 3D-002		NO.		DATE		REVISION	
PROJECT: EVENT COMPLEX QADIRABAD		NO.		DATE		REVISION	
FOR MR.GUL NAWAZ KHAN		NO.		DATE		REVISION	
PROJECT CODE:		ARCHITECTS SIGNATURE:					
DRAWING TITLE: WORKING DRAWING		DRAWING DESCRIPTION: 3D VIEWS		LOCATION: QADIRABAD			
SCALE:		DATE: MAY-2026		DRAWN BY: BH.		CHECKED BY: AR.	
KASWA DESIGN SERVICES Consulting Architect & Interior Designers 379 TARIQ BLOCK, NEW GARDEN TOWN, LAHORE 042-36858456, 0336-5858450, kaswadesign@gmail.com		ELECTRICAL CONSULTANT:					
STRUCTURAL CONSULTANT:							

[illegible]





 KASWA DESIGN SERVICES Consulting Architect & Interior Designers 379 TARIQ BLOCK, NEW GARDEN TOWN, LAHORE 042-35858456, 0336-5858450, kaswadesign@gmail.com STRUCTURAL CONSULTANT: ELECTRICAL CONSULTANT:	SCALE:		DRAWING TITLE: WORKING DRAWING	PROJECT: EVENT COMPLEX QADIRABAD FOR MR.GUL NAWAZ KHAN	DRAWING NO.:	
	DATE:	MAY-2026			NO.	DATE
	DRAWN BY:	B.H.	LOCATION QADIRABAD	PROJECT CODE:		REVISION
	CHECKED BY:	A.R.		ARCHITECTS SIGNATURE:		

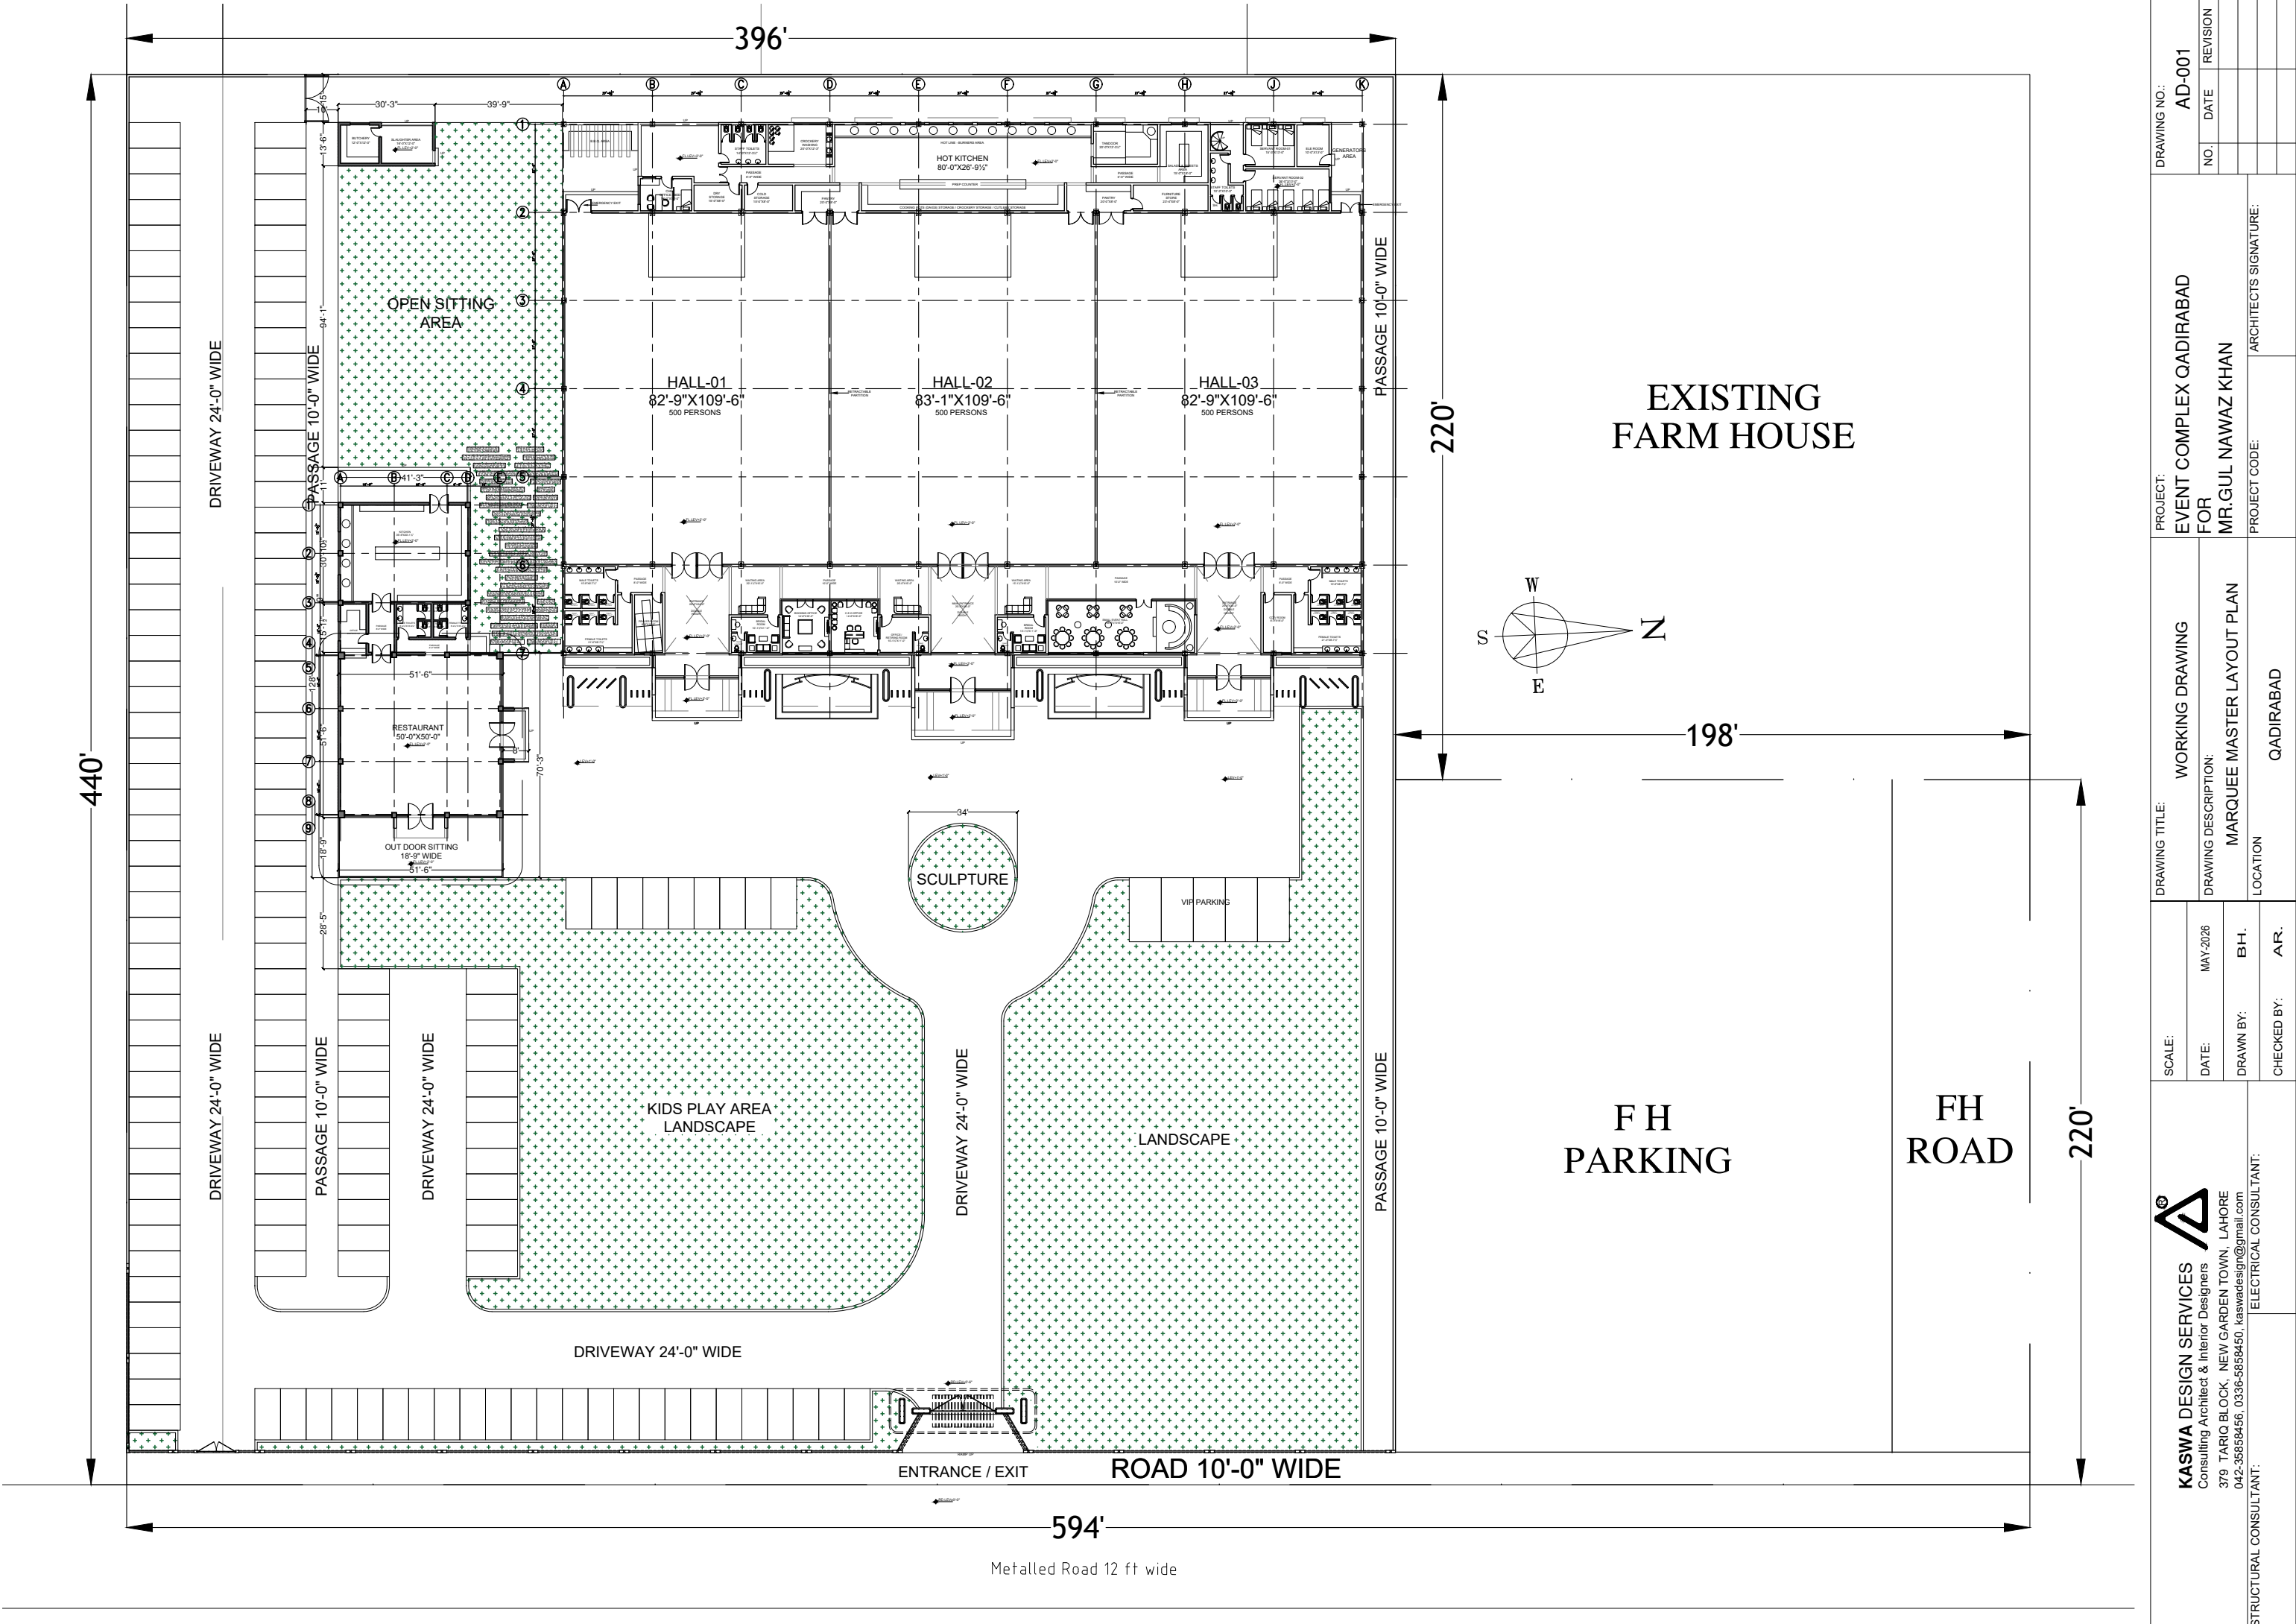


DRAWING NO.: AD-001		PROJECT: EVENT COMPLEX QADIRABAD	
NO.		FOR MR. GUL NAWAZ KHAN	
DATE		ARCHITECT'S SIGNATURE:	
REVISION		PROJECT CODE:	
		QADIRABAD	
DRAWING TITLE: WORKING DRAWING		DRAWING DESCRIPTION: MARQUEE MASTER LAYOUT PLAN	
SCALE:		LOCATION	
DATE: MAY-2026		BY: BH.	
DRAWN BY:		CHECKED BY: AR.	
STRUCTURAL CONSULTANT:		ELECTRICAL CONSULTANT:	
KASWA DESIGN SERVICES		KASWA DESIGN SERVICES	
Consulting Architect & Interior Designers		Consulting Architect & Interior Designers	
379 TARIQ BLOCK, NEW GARDEN TOWN, LAHORE		379 TARIQ BLOCK, NEW GARDEN TOWN, LAHORE	
042-36858456, 0336-5858450, kaswadesign@gmail.com		042-36858456, 0336-5858450, kaswadesign@gmail.com	




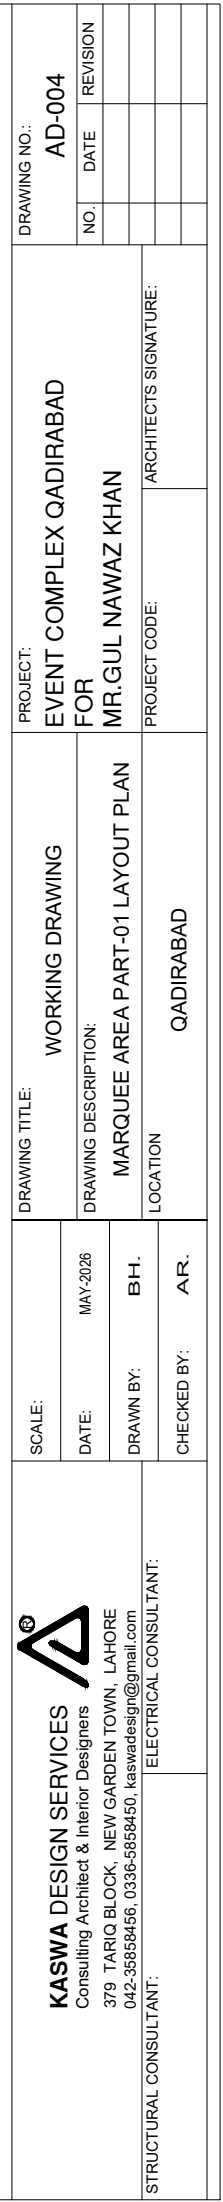

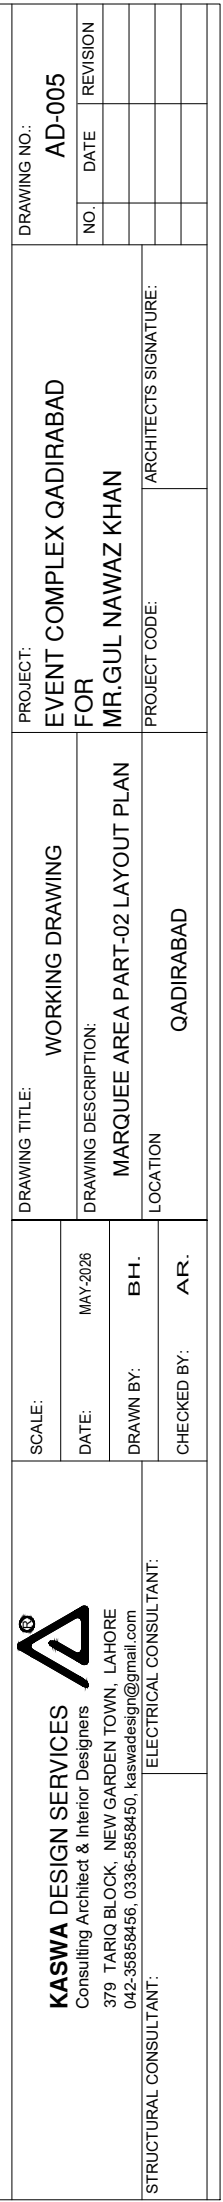

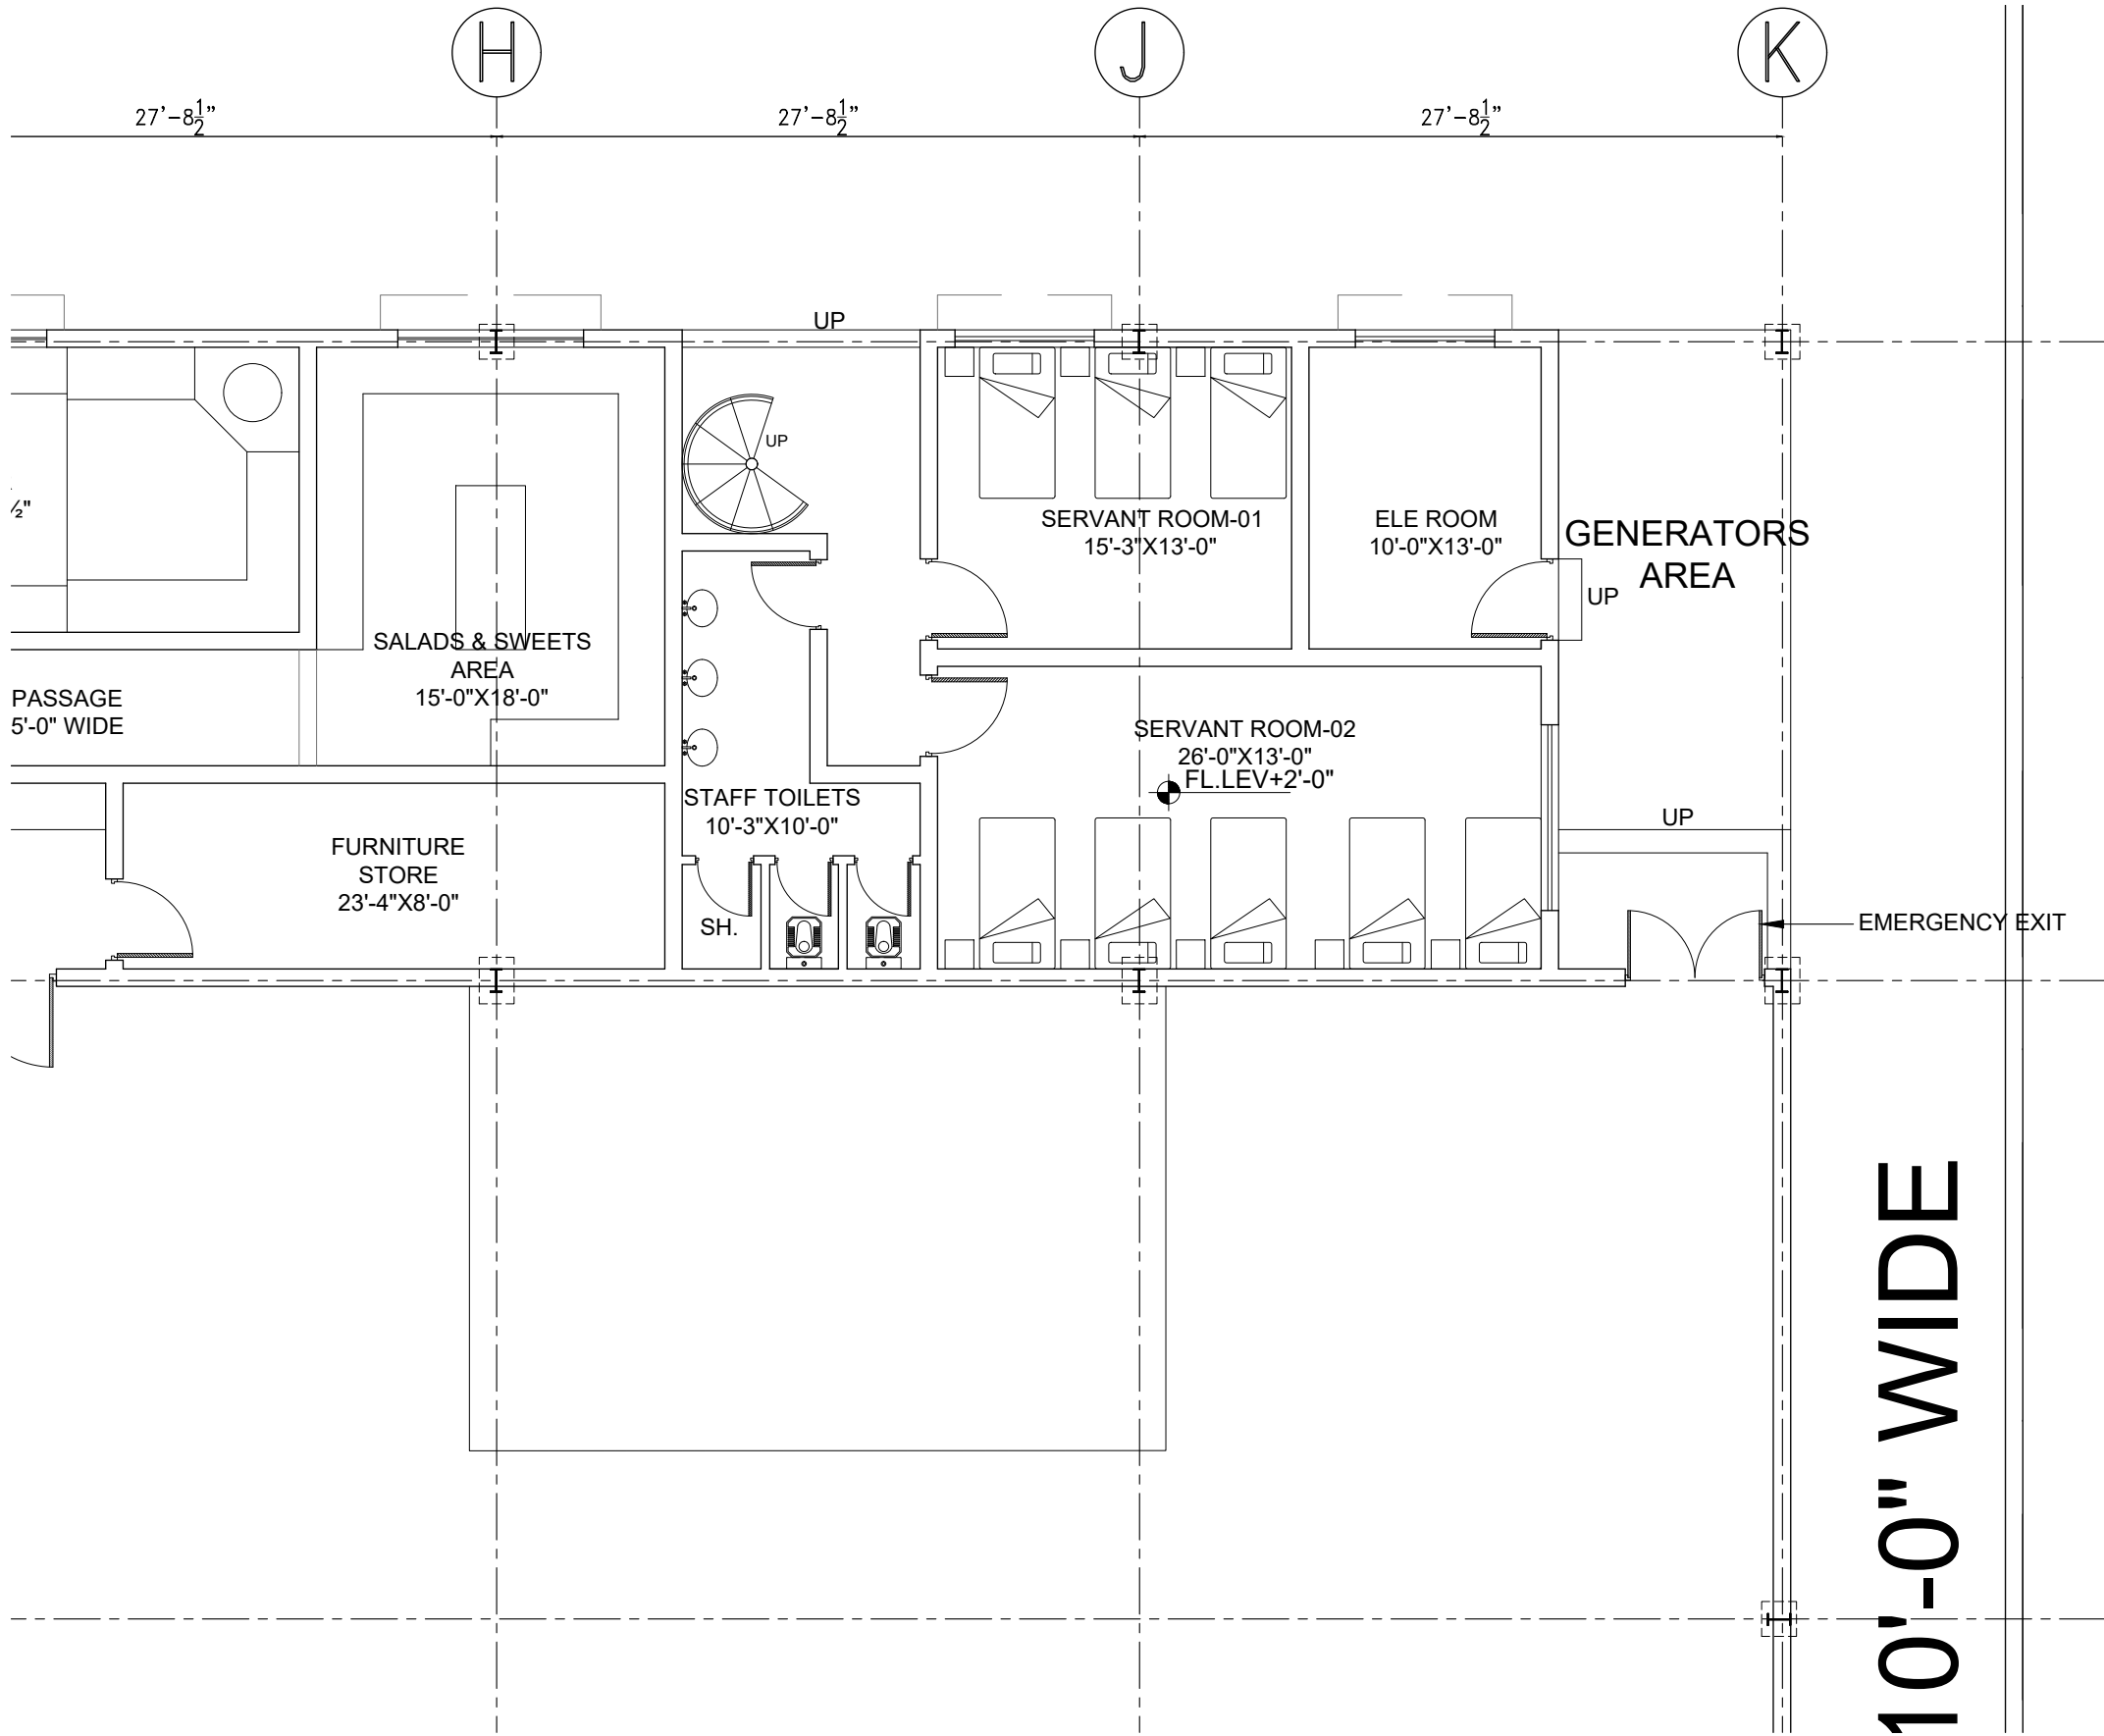

KASWA DESIGN SERVICES Consulting Architect & Interior Designers 379 TARIQ BLOCK, NEW GARDEN TOWN, LAHORE 042-35858456, 0336-5858450, kaswadesign@gmail.com ELECTRICAL CONSULTANT: STRUCTURAL CONSULTANT:	SCALE:	WORKING DRAWING	PROJECT:	DRAWING NO.:			
	DATE:	MAY-2026	DRAWING DESCRIPTION:	EVENT COMPLEX QADIRABAD	NO.	DATE	REVISION
	DRAWN BY:	BH.	MARQUEE AREA PART-03 LAYOUT PLAN	FOR			
	CHECKED BY:	AR.	LOCATION	MR.GUL NAWAZ KHAN			
			QADIRABAD	ARCHITECTS SIGNATURE:			

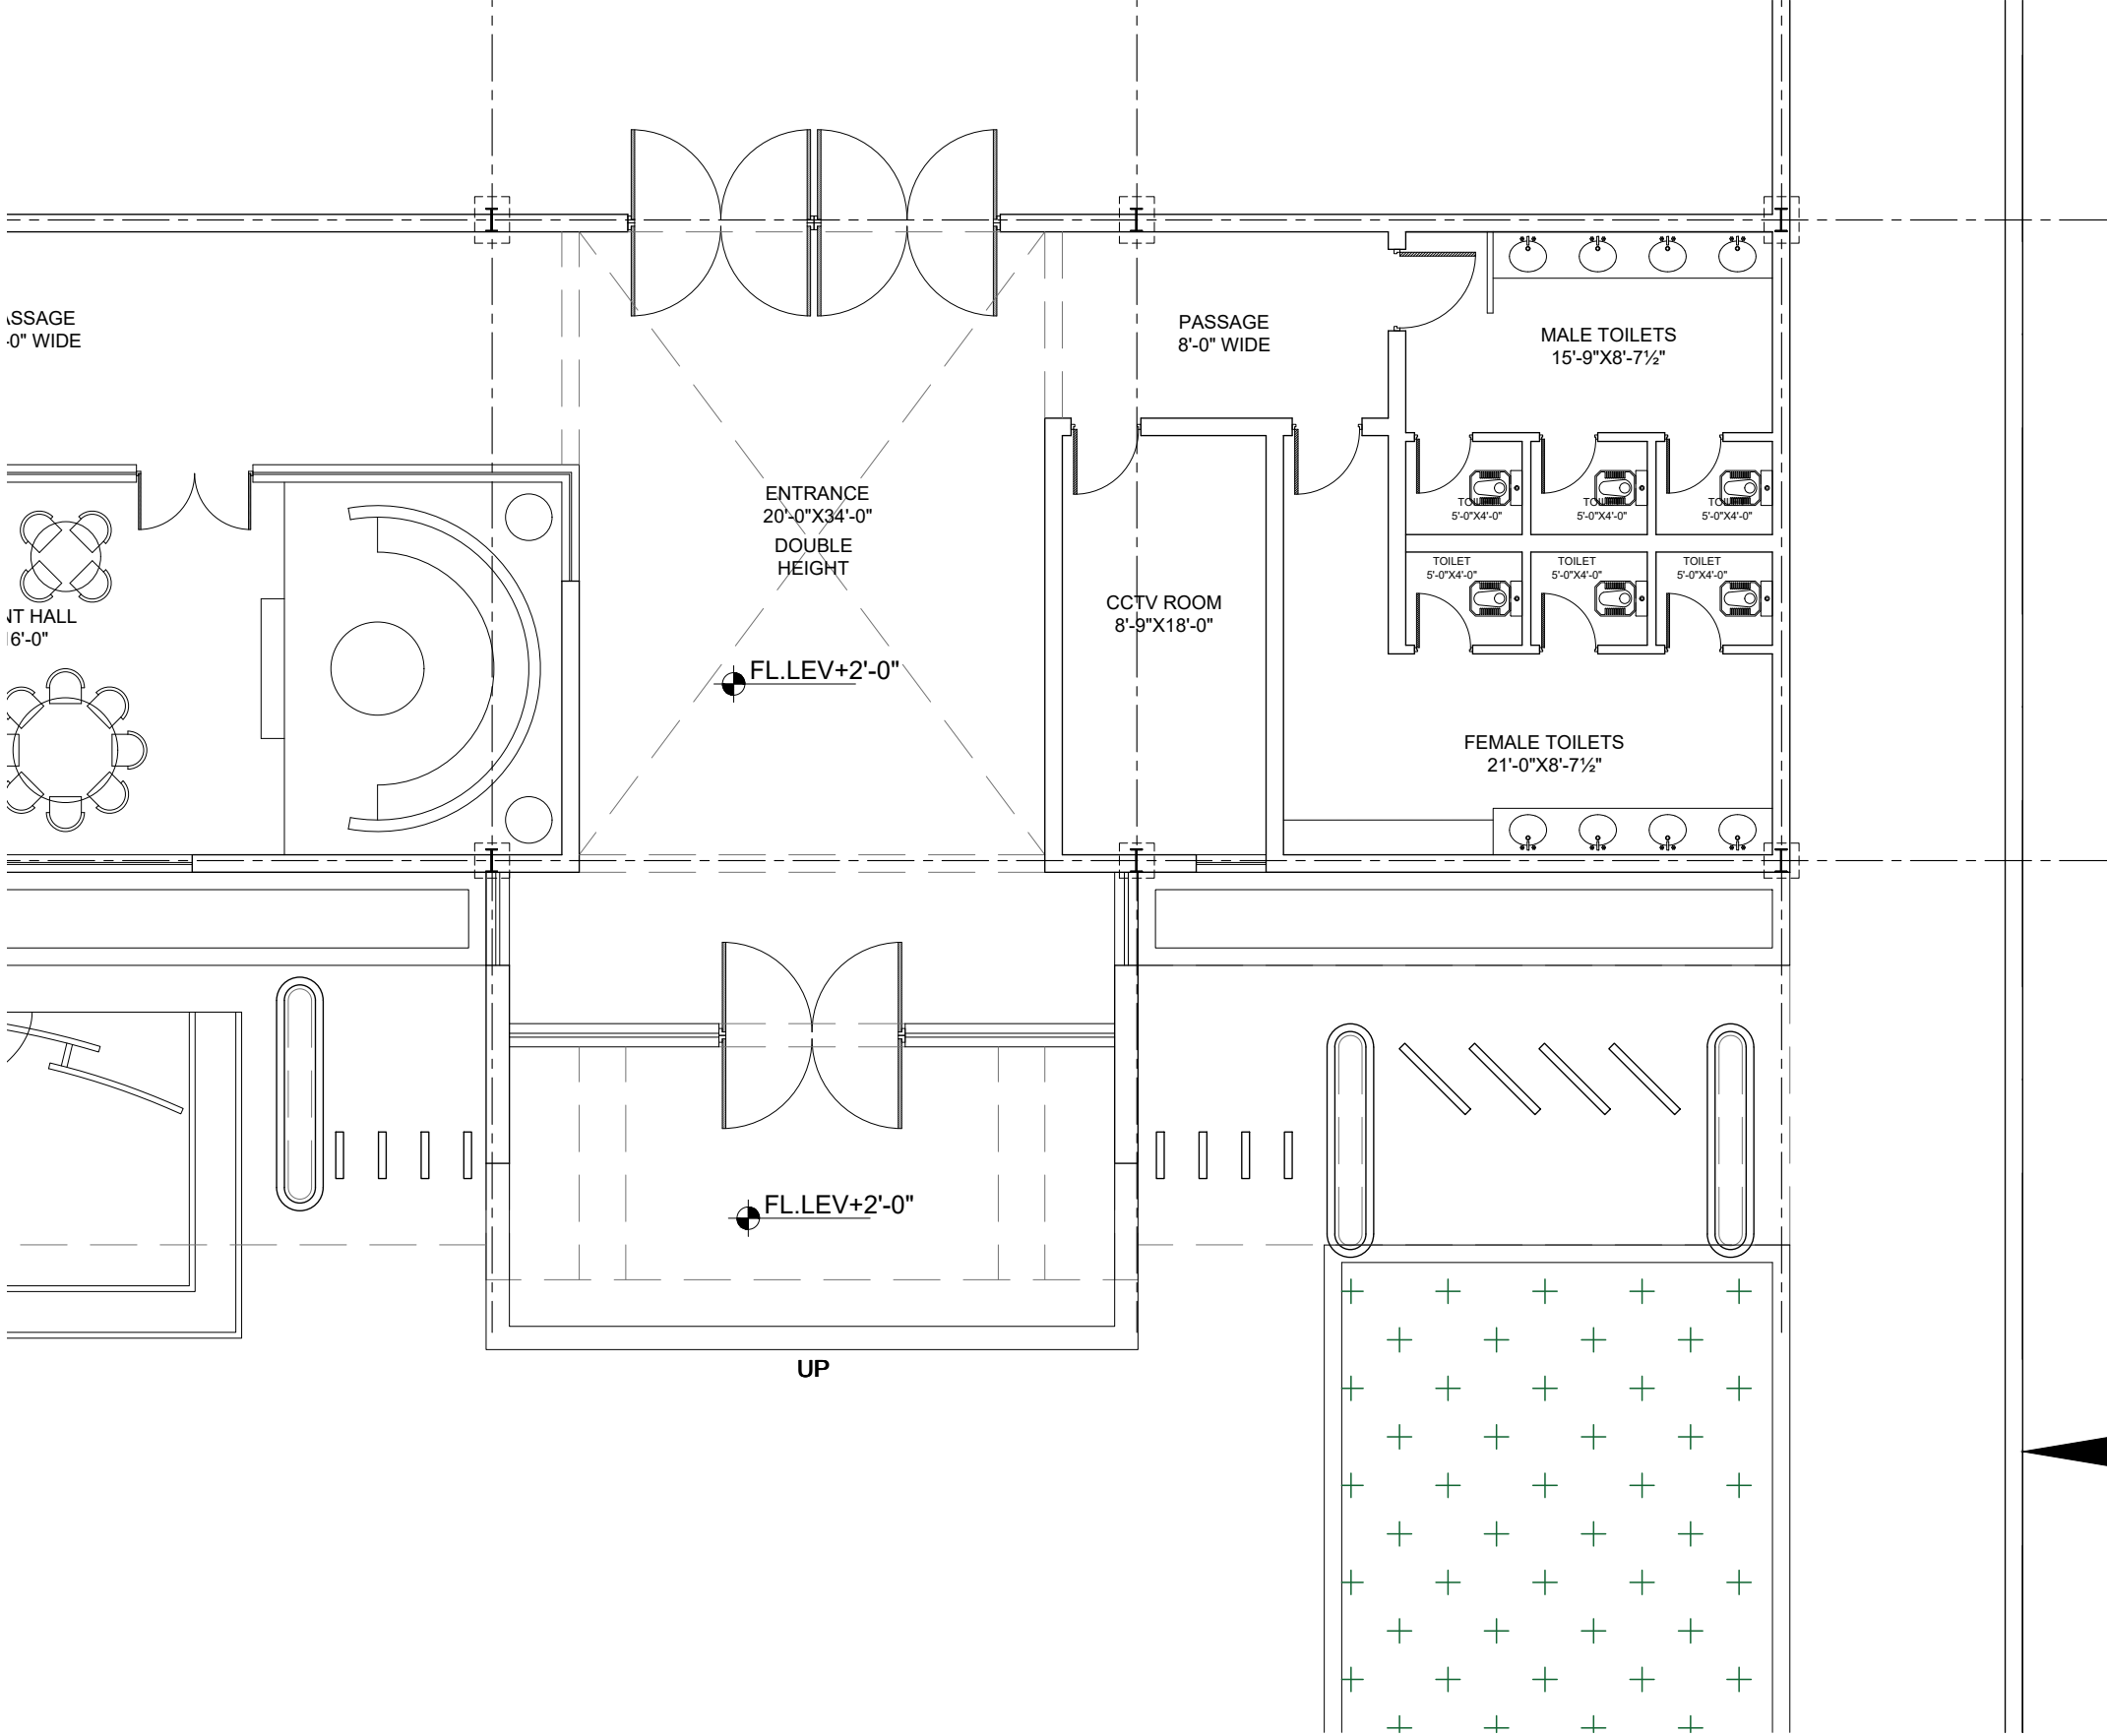

KASWA DESIGN SERVICES
Consulting Architect & Interior Designers
379 TARIQ BLOCK, NEW GARDEN TOWN, LAHORE
042-35858456, 0336-5858450, kaswadesign@gmail.com

ELECTRICAL CONSULTANT:

SCALE:

DATE: MAY-2026

DRAWN BY: BH.

CHECKED BY: AR.

DRAWING TITLE: WORKING DRAWING

DRAWING DESCRIPTION: MARQUEE AREA PART-04 LAYOUT PLAN

LOCATION


QADIRABAD

PROJECT: EVENT COMPLEX QADIRABAD
FOR MR. GUL NAWAZ KHAN

PROJECT CODE: ARCHITECT'S SIGNATURE:

DRAWING NO.: AD-007

NO. DATE REVISION

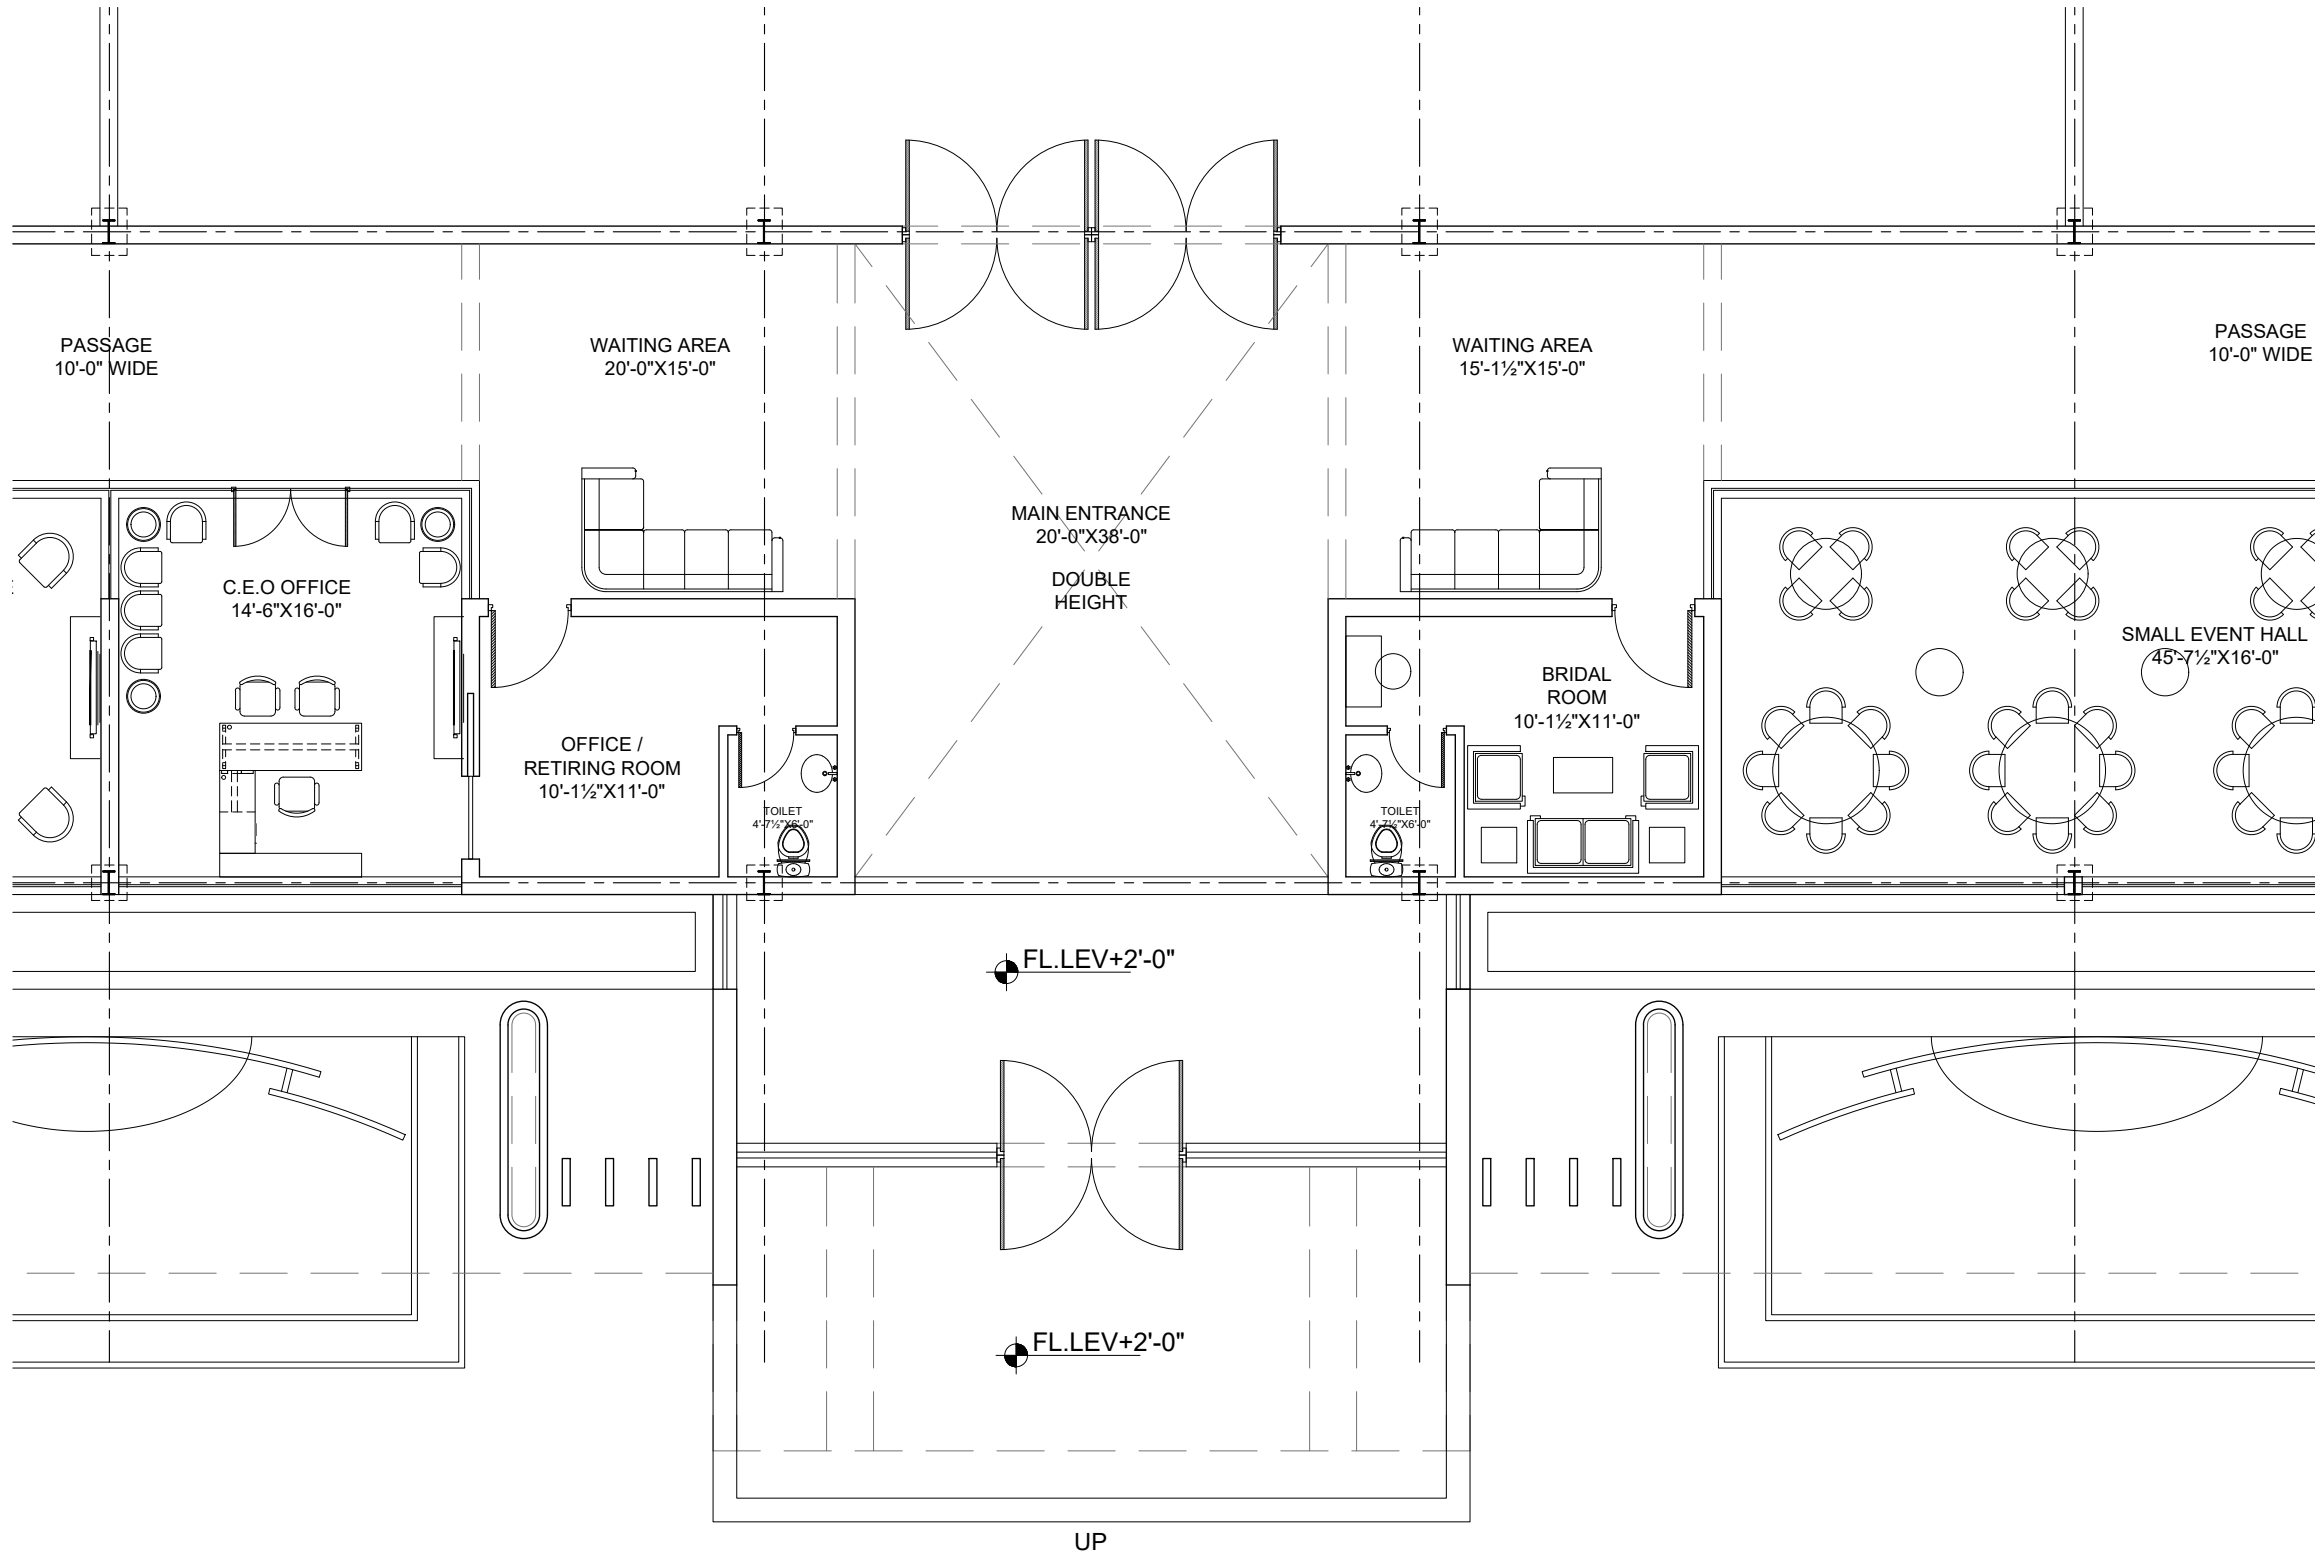

KASWA DESIGN SERVICES
Consulting Architect & Interior Designers
379 TARIQ BLOCK, NEW GARDEN TOWN, LAHORE
042-35858456, 0336-5858450, kaswadesign@gmail.com

ELECTRICAL CONSULTANT:


SCALE:
DATE: MAY-2026
DRAWN BY: BH.
CHECKED BY: AR.

DRAWING TITLE: WORKING DRAWING
DRAWING DESCRIPTION: MARQUEE AREA PART-05 LAYOUT PLAN
LOCATION: QADIRABAD


PROJECT: EVENT COMPLEX QADIRABAD
FOR MR.GUL NAWAZ KHAN
PROJECT CODE: ARCHITECTS SIGNATURE:

DRAWING NO.: AD-008

NO.	DATE	REVISION

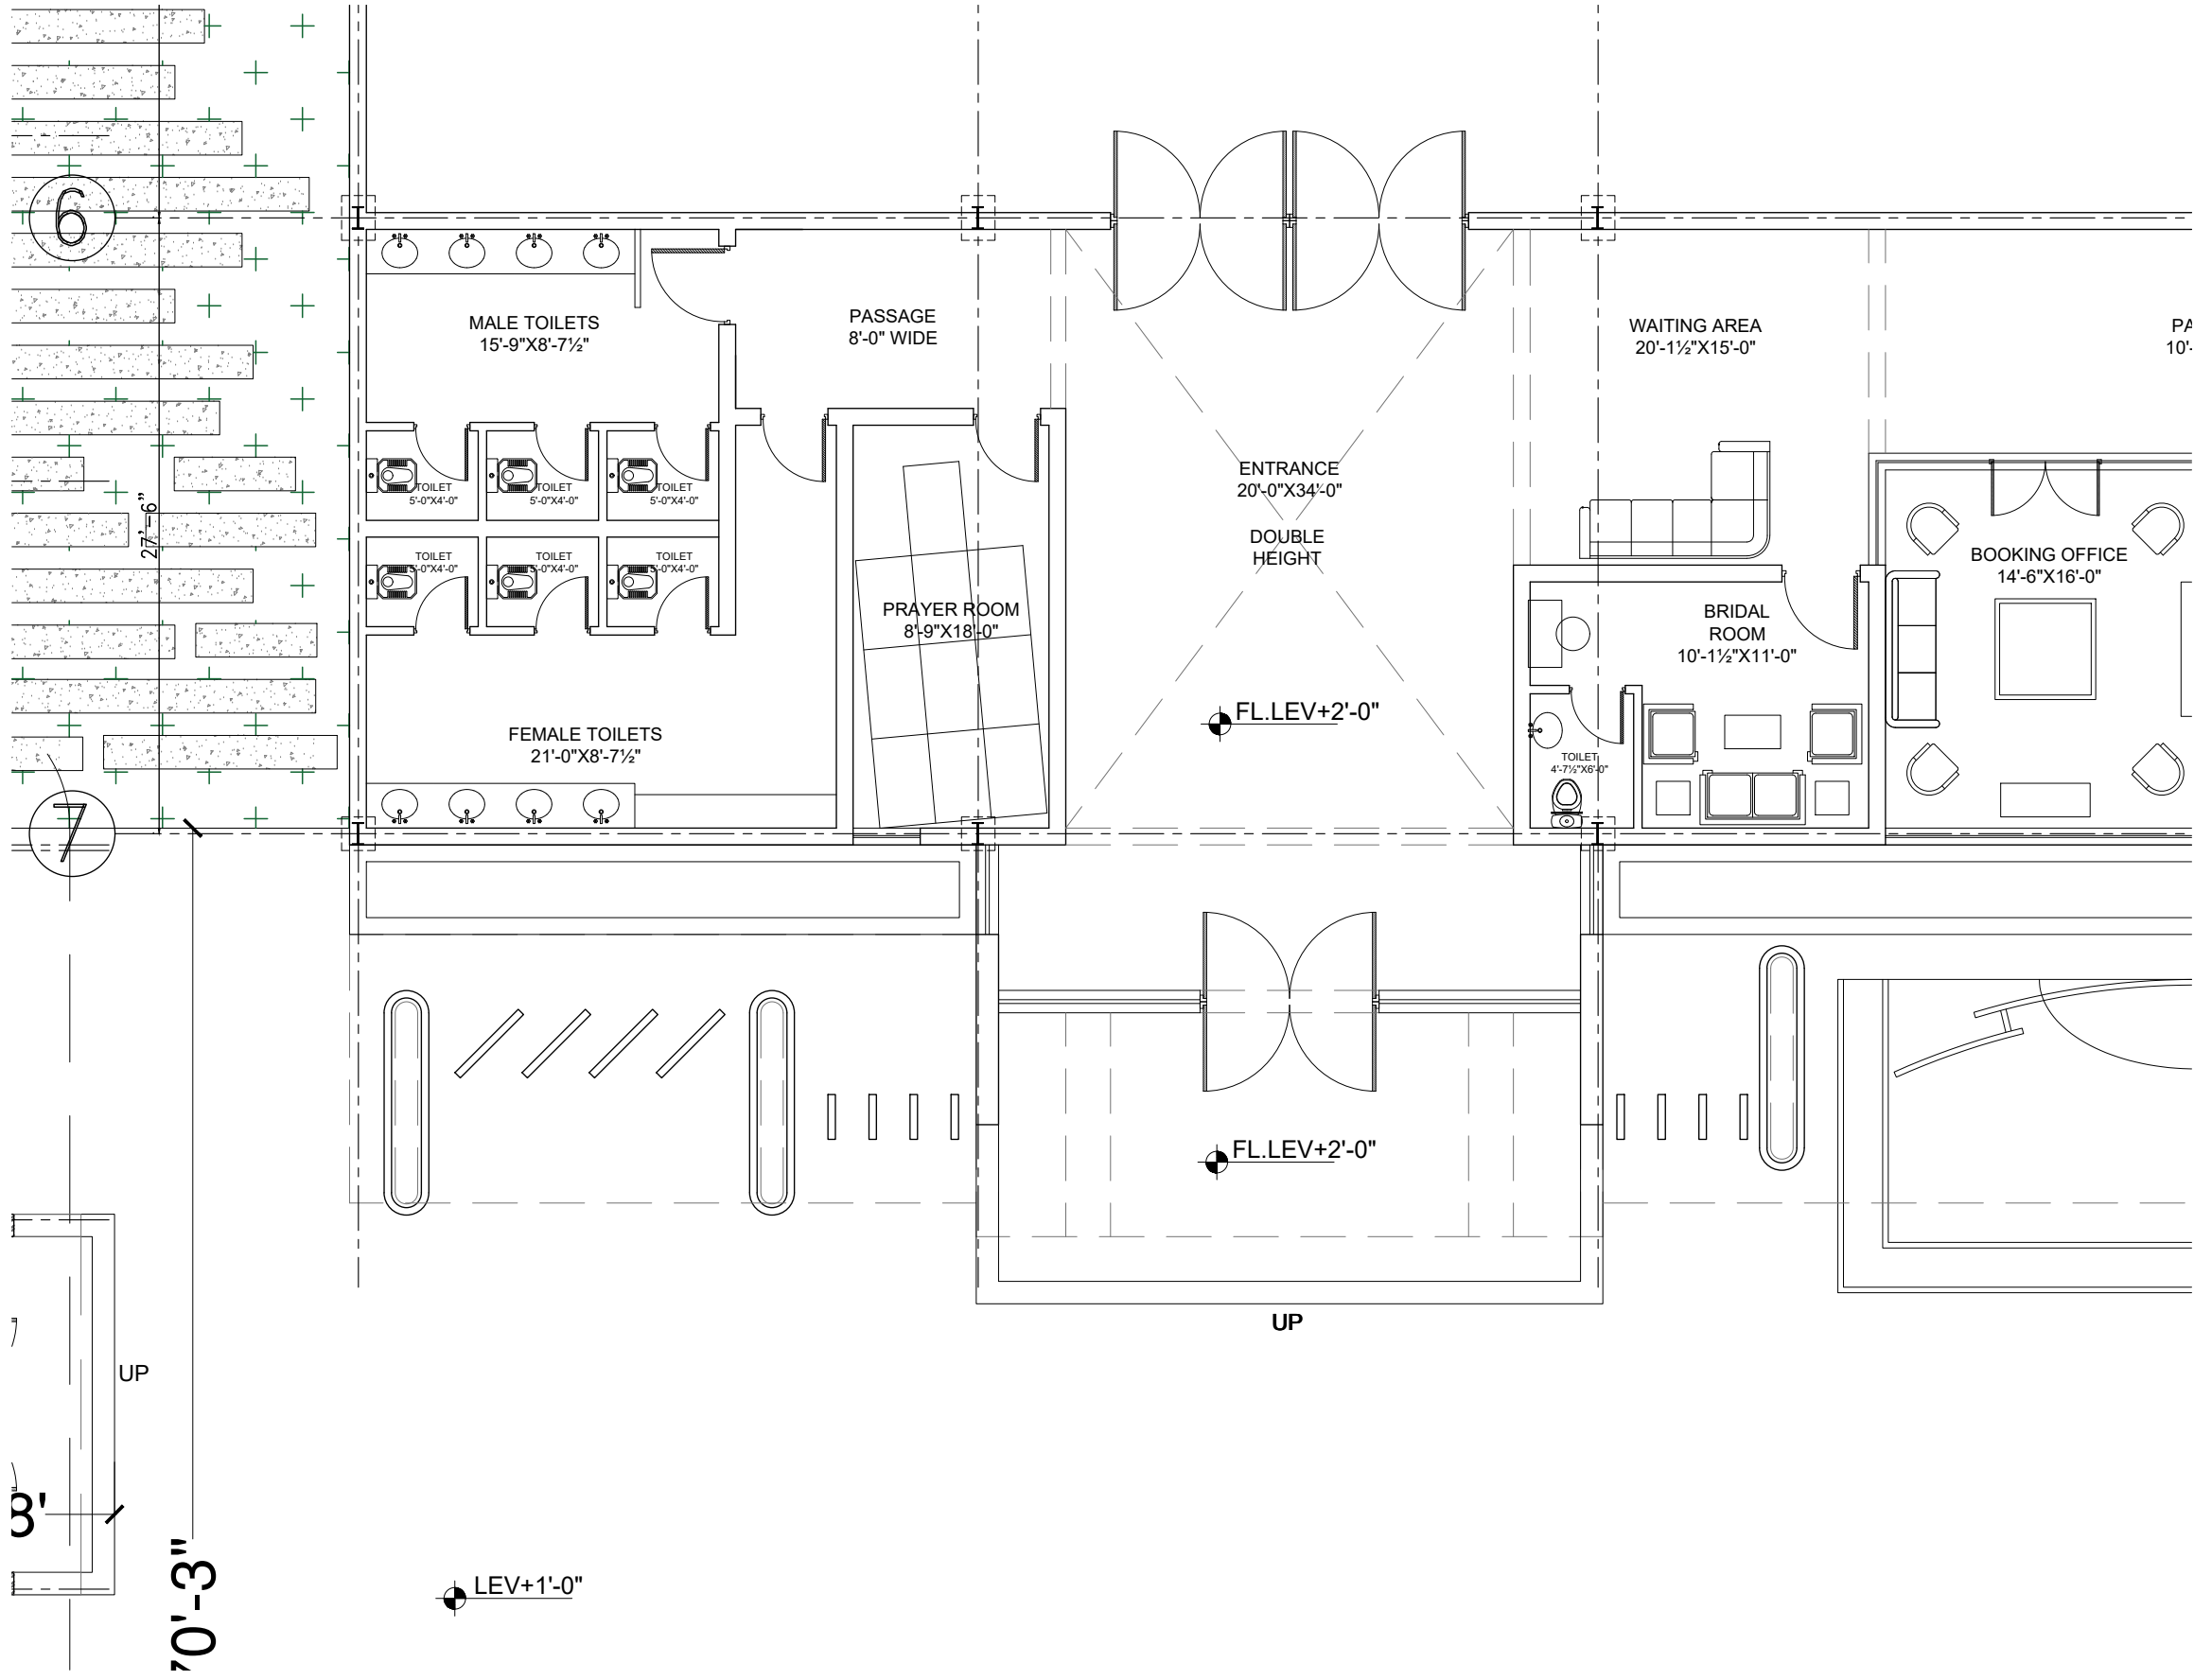


KASWA DESIGN SERVICES Consulting Architect & Interior Designers 379 TARIQ BLOCK, NEW GARDEN TOWN, LAHORE 042-35858456, 0336-5858450, kaswadesign@gmail.com		DRAWING NO.: AD-009	
		NO.	REVISION
STRUCTURAL CONSULTANT:		PROJECT: EVENT COMPLEX QADIRABAD	
		FOR MR.GUL NAWAZ KHAN	
ELECTRICAL CONSULTANT:		PROJECT CODE:	
		ARCHITECTS SIGNATURE:	
DRAWING TITLE: WORKING DRAWING		LOCATION: QADIRABAD	
SCALE: MAY-2026		DRAWING DESCRIPTION: MARQUEE AREA PART-06 LAYOUT PLAN	
DATE: BH.		CHECKED BY: AR.	
DRAWN BY: BH.		ARCHITECTS SIGNATURE:	
CHECKED BY: AR.		ARCHITECTS SIGNATURE:	

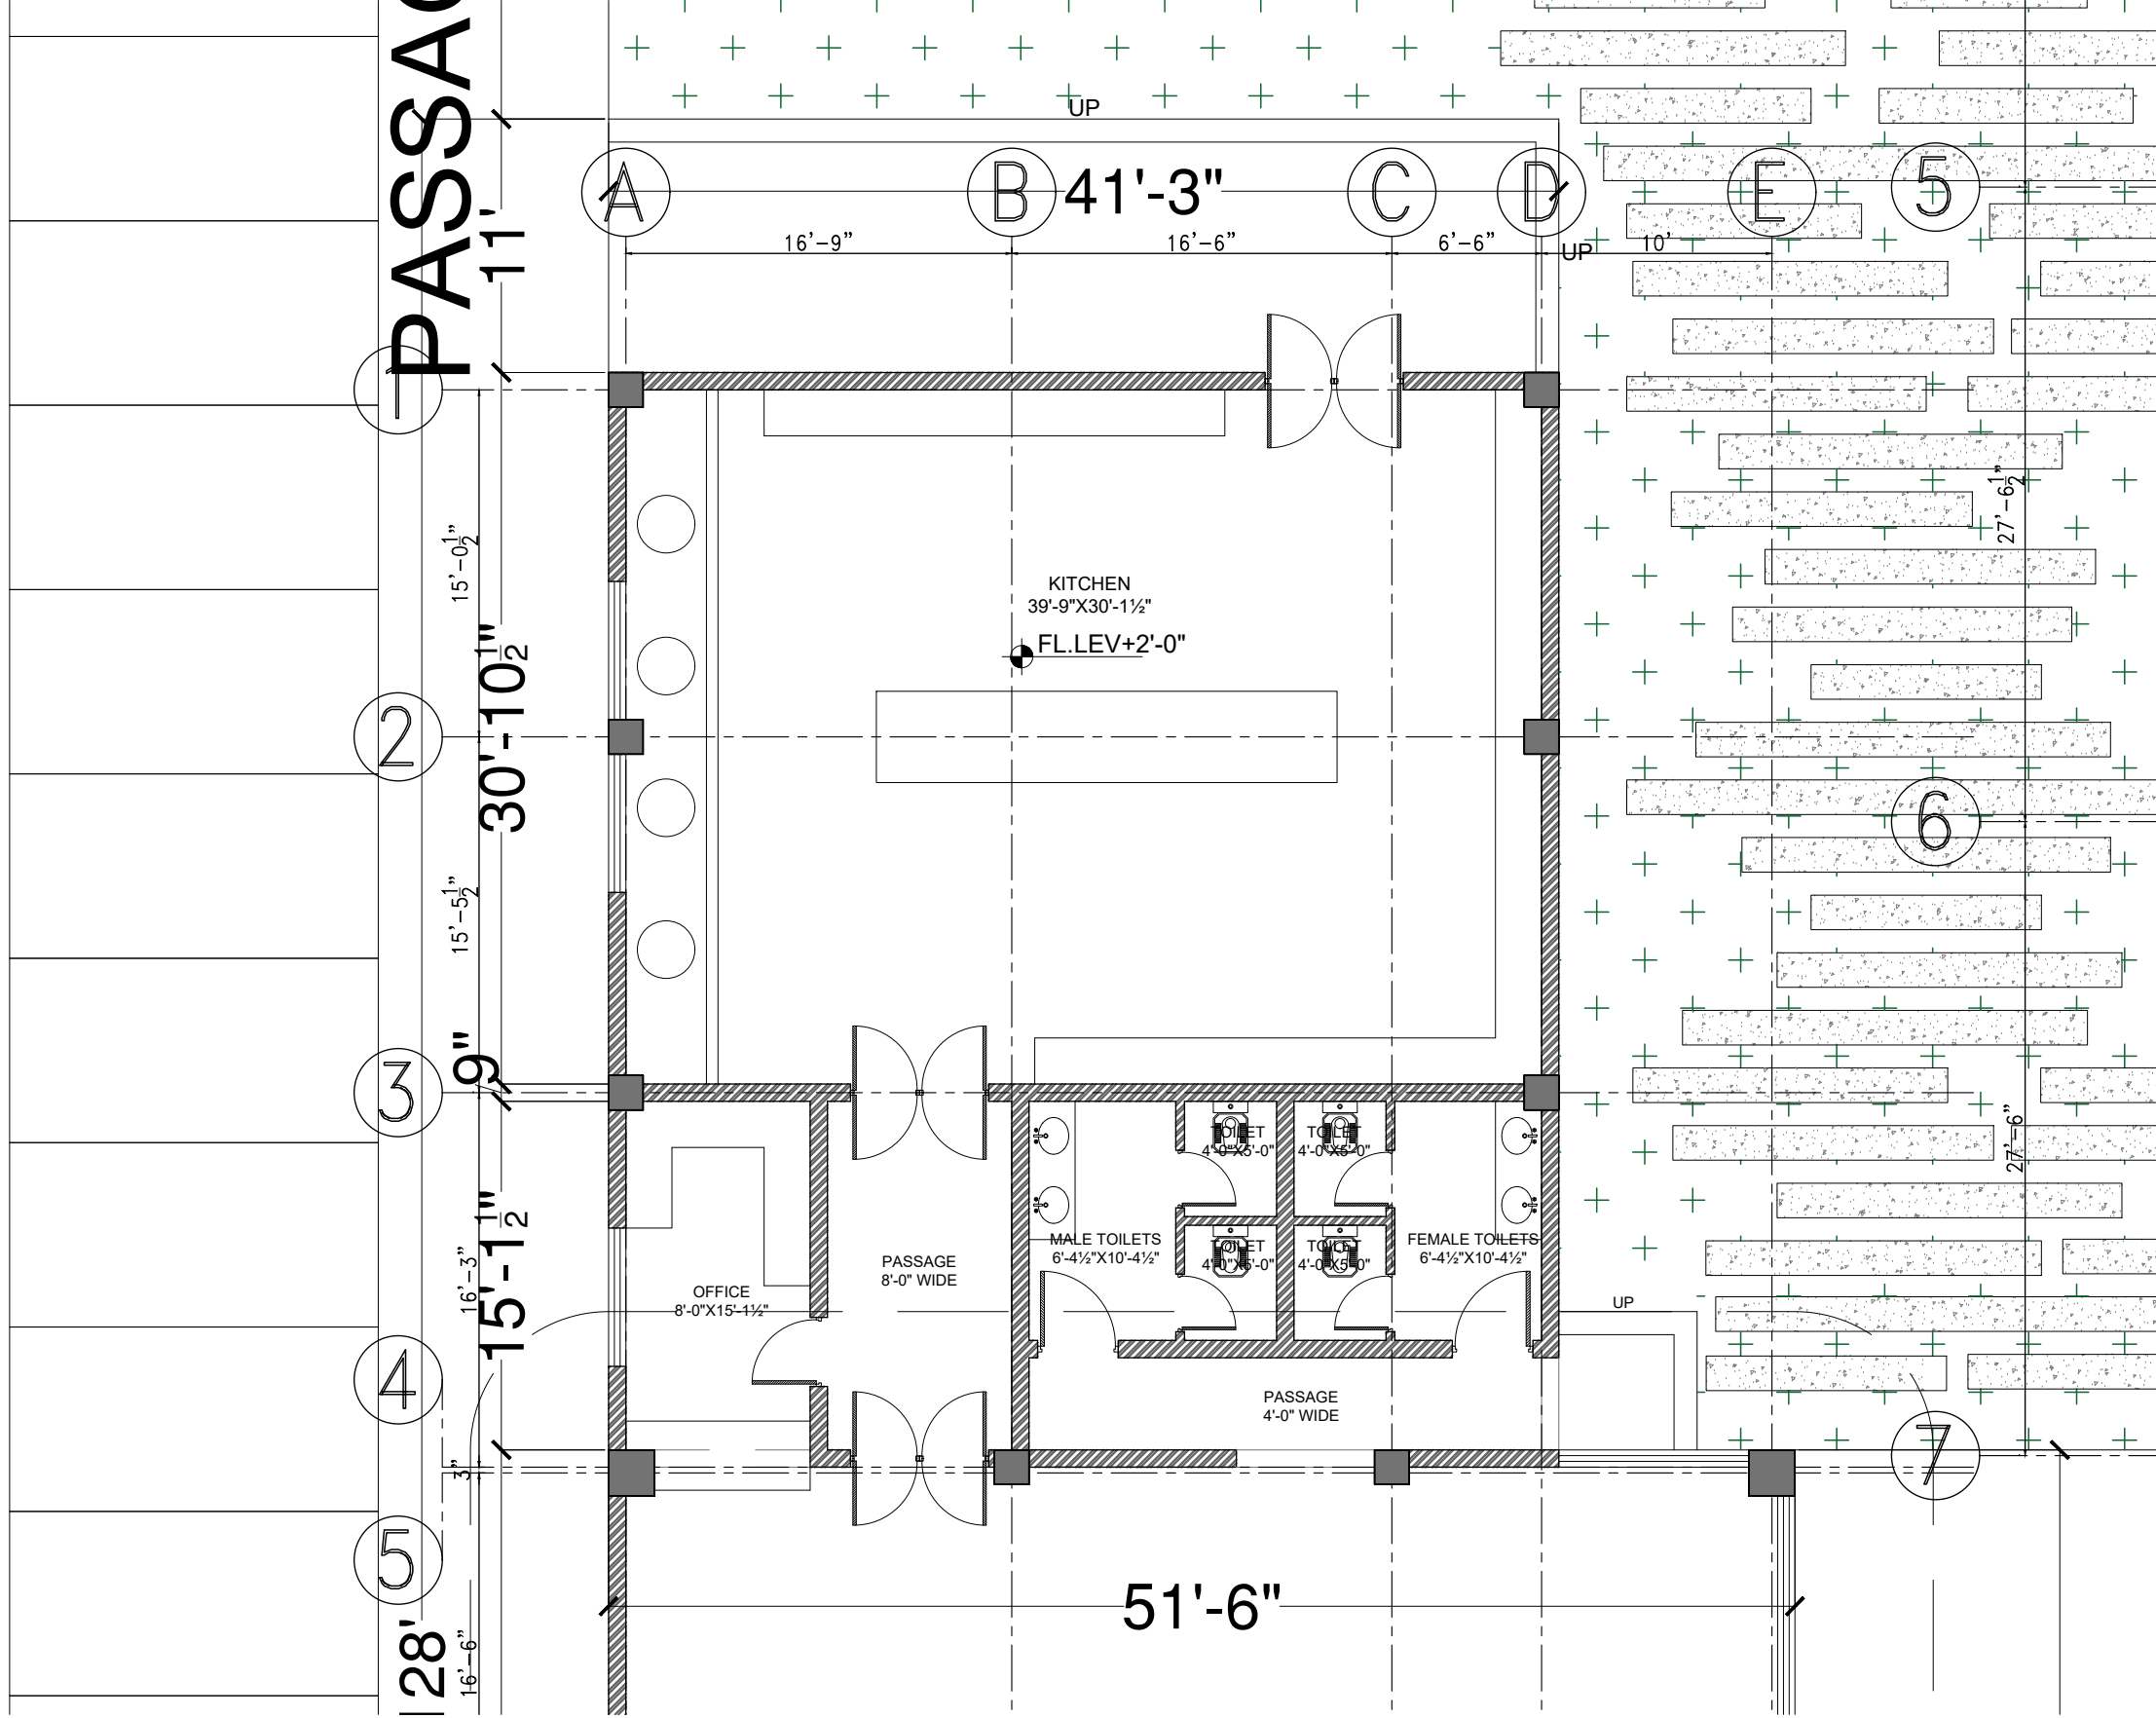

KASWA DESIGN SERVICES Consulting Architect & Interior Designers 379 TARIQ BLOCK, NEW GARDEN TOWN, LAHORE 042-35858456, 0336-5858450, kaswadesign@gmail.com ELECTRICAL CONSULTANT:	SCALE:		DRAWING TITLE:		PROJECT:		DRAWING NO.:	
	DATE:		DRAWING DESCRIPTION:		EVENT COMPLEX QADIRABAD		AD-010	
	DRAWN BY:		LOCATION		FOR MR. GUL NAWAZ KHAN		REVISION	
			B.H.		QADIRABAD			
			A.R.		ARCHITECTS SIGNATURE:			
STRUCTURAL CONSULTANT:		CHECKED BY:		PROJECT CODE:				



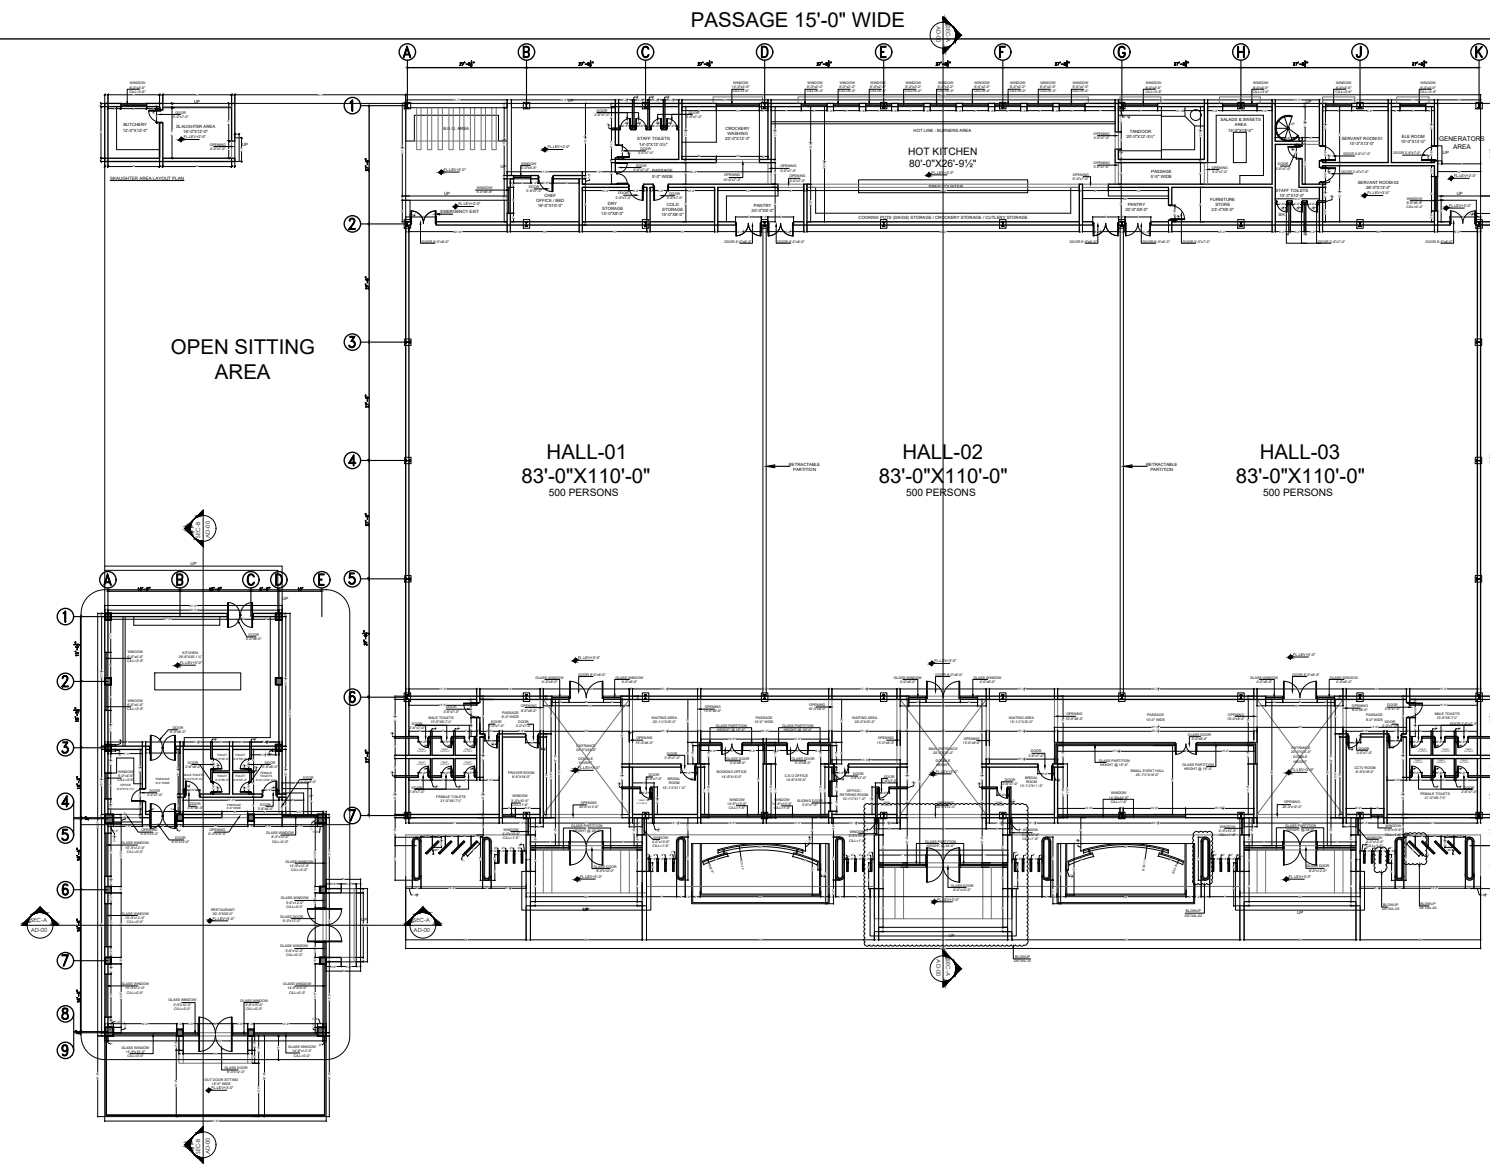

OPEN SITTING
AREA


HALL-01
83'-0"X110'-0"
500 PERSONS

HALL-02
83'-0"X110'-0"
500 PERSONS

HALL-03
83'-0"X110'-0"
500 PERSONS

PASSAGE 10'-0" WIDE

EXISTING FARM HOUSE

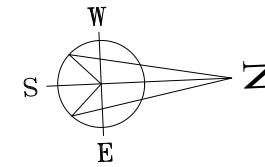

F H
PARKING

FH
ROAD

220'

ROAD 10'-0" WIDE

—594—

Metalled Road 12 ft wide

**KASWA DESIGN SERVICES**
Consulting Architect & Interior Designers
379 TARIQ BLOCK, NEW GARDEN TOWN, LAHORE
042-35858456, 0336-5958450, kaswadesign@gmail.com
ELECTRICAL CONSULTANT:

042-36858456, 0336-3658450, kaswadesign@gmail.com	
STRUCTURAL CONSULTANT:	ELECTRICAL CONSULTANT:

SCALE:	
DATE:	MAY-2026
DRAWN BY:	BH.
CHECKED BY:	AR.

DRAWING TITLE:

LOCATION	QADIRABAD
1	1
2	2
3	3
100	100

PROJECT:	
EVENT COMPLEX QADIRABAD	
FOR	
MR.GUL NAWAZ KHAN	
PROJECT CODE:	ARCHITECTS S

DRAWING NO.:
AD-012

NO.	DATE	REVISION

A circular logo with the text "SEC-A" at the top and "AD-00" at the bottom. A black triangle is positioned to the right of the circle, pointing towards it.




KASWA DESIGN SERVICES
Consulting Architect & Interior Designers
379 TARIQ BLOCK, NEW GARDEN TOWN, LAHORE
042-35858456, 0336-5858450, kaswadesign@gmail.com

STRUCTURAL CONSULTANT: ELECTRICAL CONSULTANT:

DRAWING TITLE:		WORKING DRAWING		PROJECT:	
DRAWING DESCRIPTION:		MARQUEE AREA WORKING LAYOUT PLAN		EVENT COMPLEX QADIRABAD FOR MR.GUL NAWAZ KHAN	
LOCATION		QADIRABAD		PROJECT CODE:	
				ARCHITECTS S	

DRAWING NO.: AD-013		
NO.	DATE	REVISION

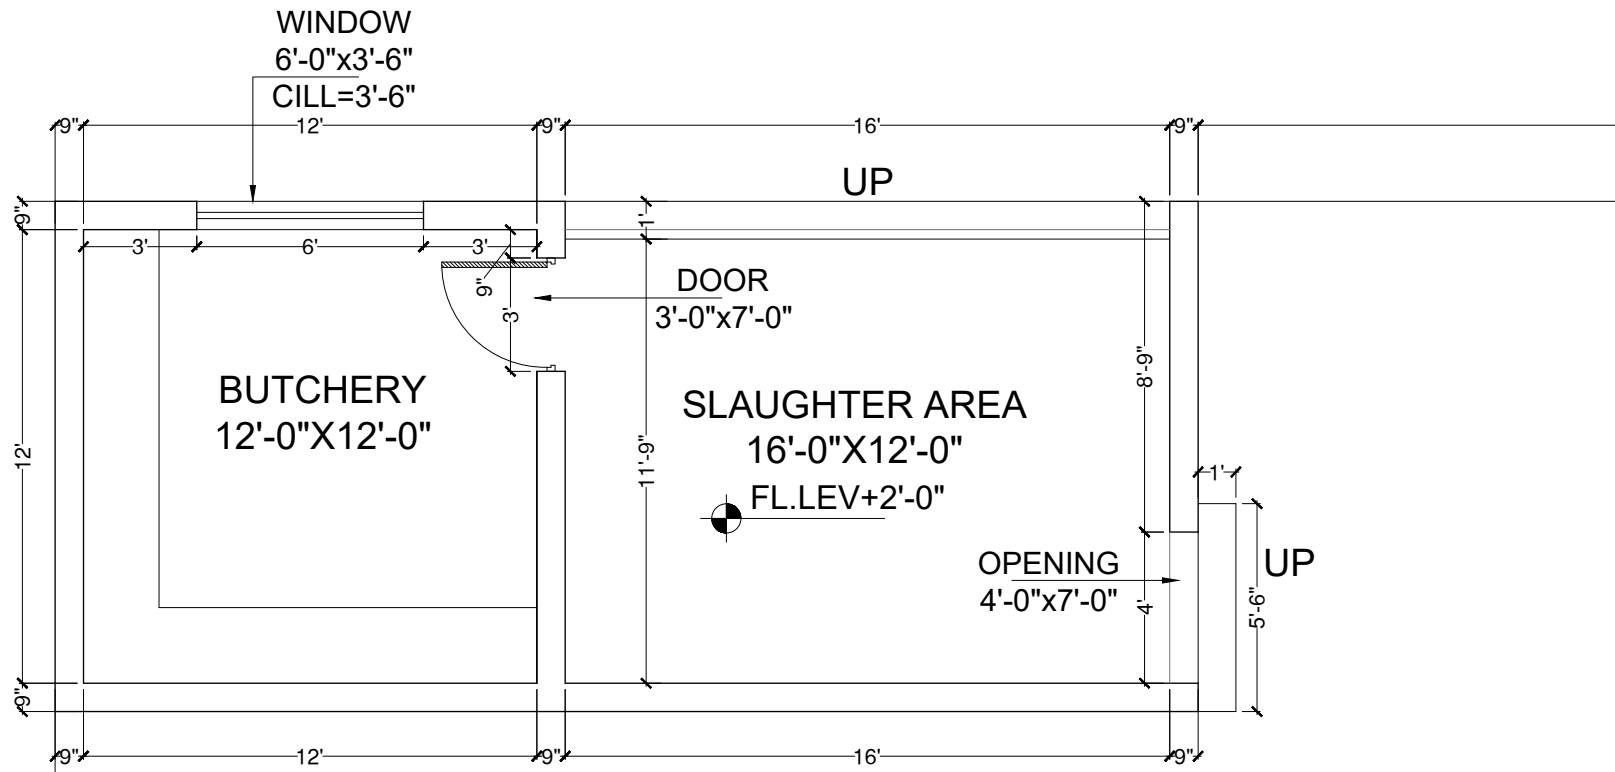

SKAUGHTER AREA LAYOUT PLAN

KASWA DESIGN SERVICES
Consulting Architect & Interior Designers
379 TARIQ BLOCK, NEW GARDEN TOWN, LAHORE
042-35858456, 0336-5858450, kaswadesign@gmail.com


STRUCTURAL CONSULTANT: ELECTRICAL CONSULTANT:

SCALE:
DATE: MAY-2026
DRAWN BY: BH.
CHECKED BY: AR.


DRAWING TITLE:
WORKING DRAWING
DRAWING DESCRIPTION:
SLAUGHTER AREA WORKING
LAYOUT PLAN
LOCATION
QADIRABAD

PROJECT:
EVENT COMPLEX QADIRABAD
FOR
MR.GUL NAWAZ KHAN
PROJECT CODE:
ARCHITECTS SIGNATURE:


DRAWING NO.:		AD-014	
NO.	DATE	REVISION	

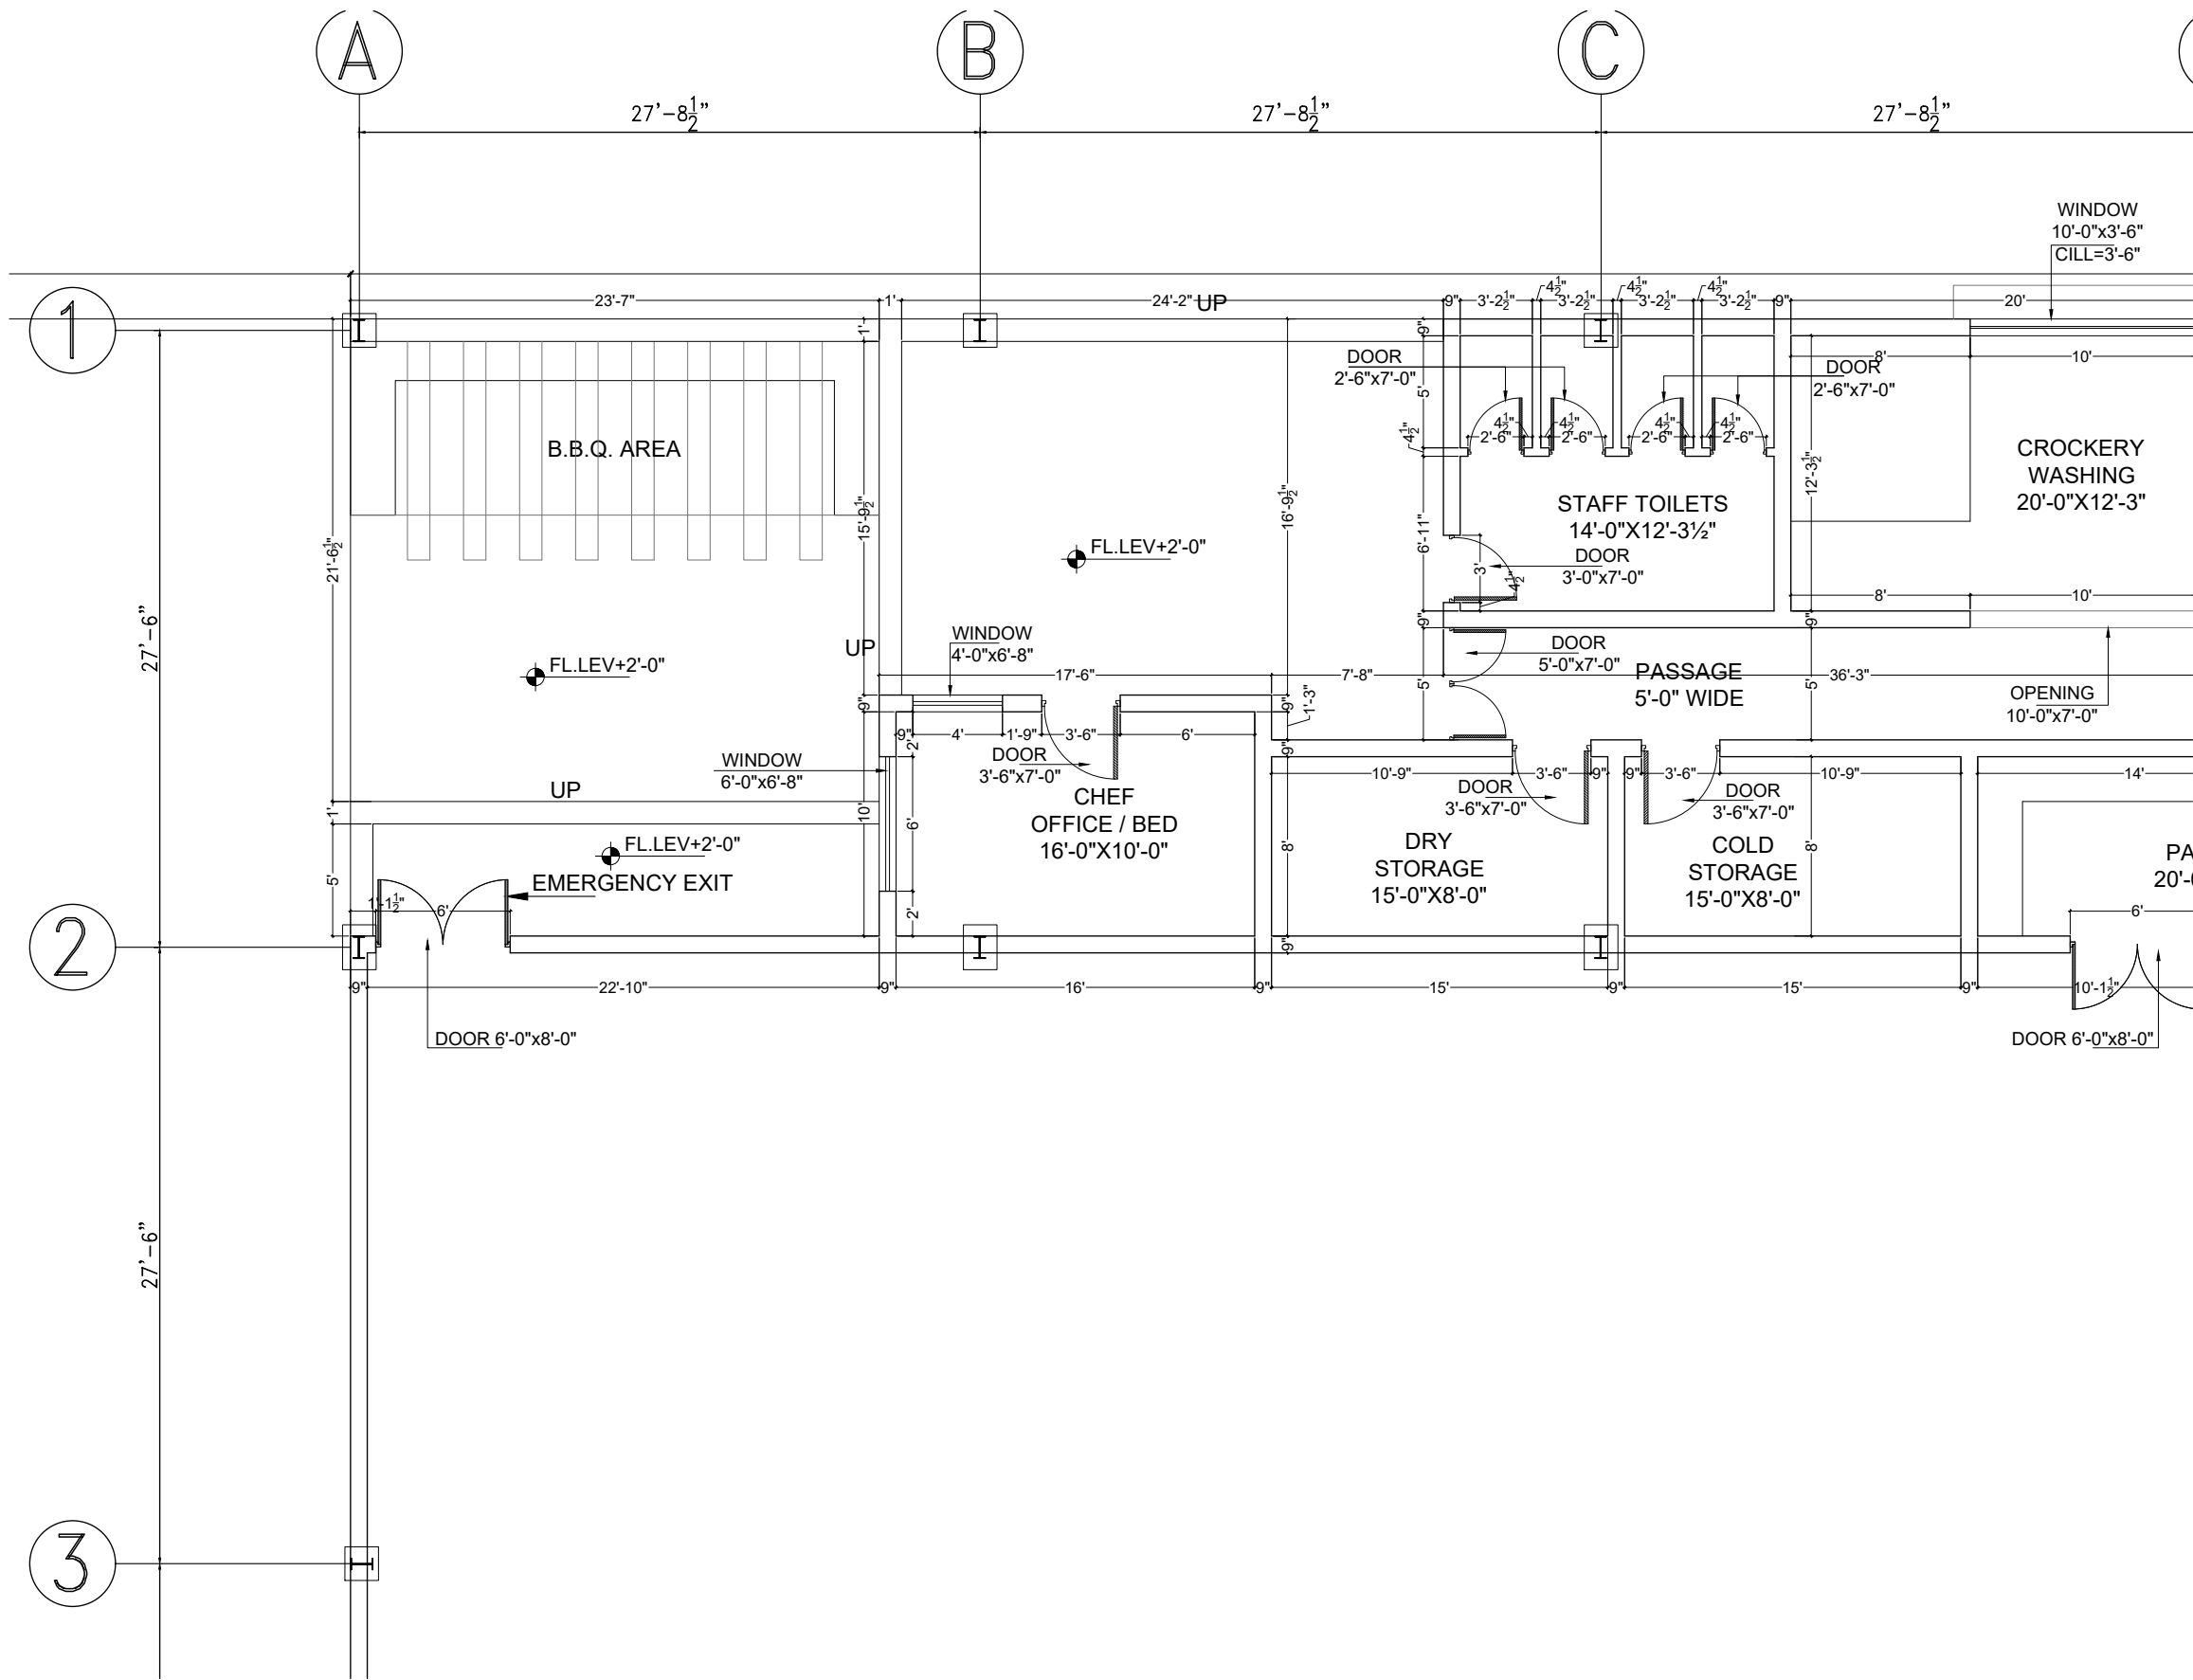


PASSAGE 15'-0" WIDE


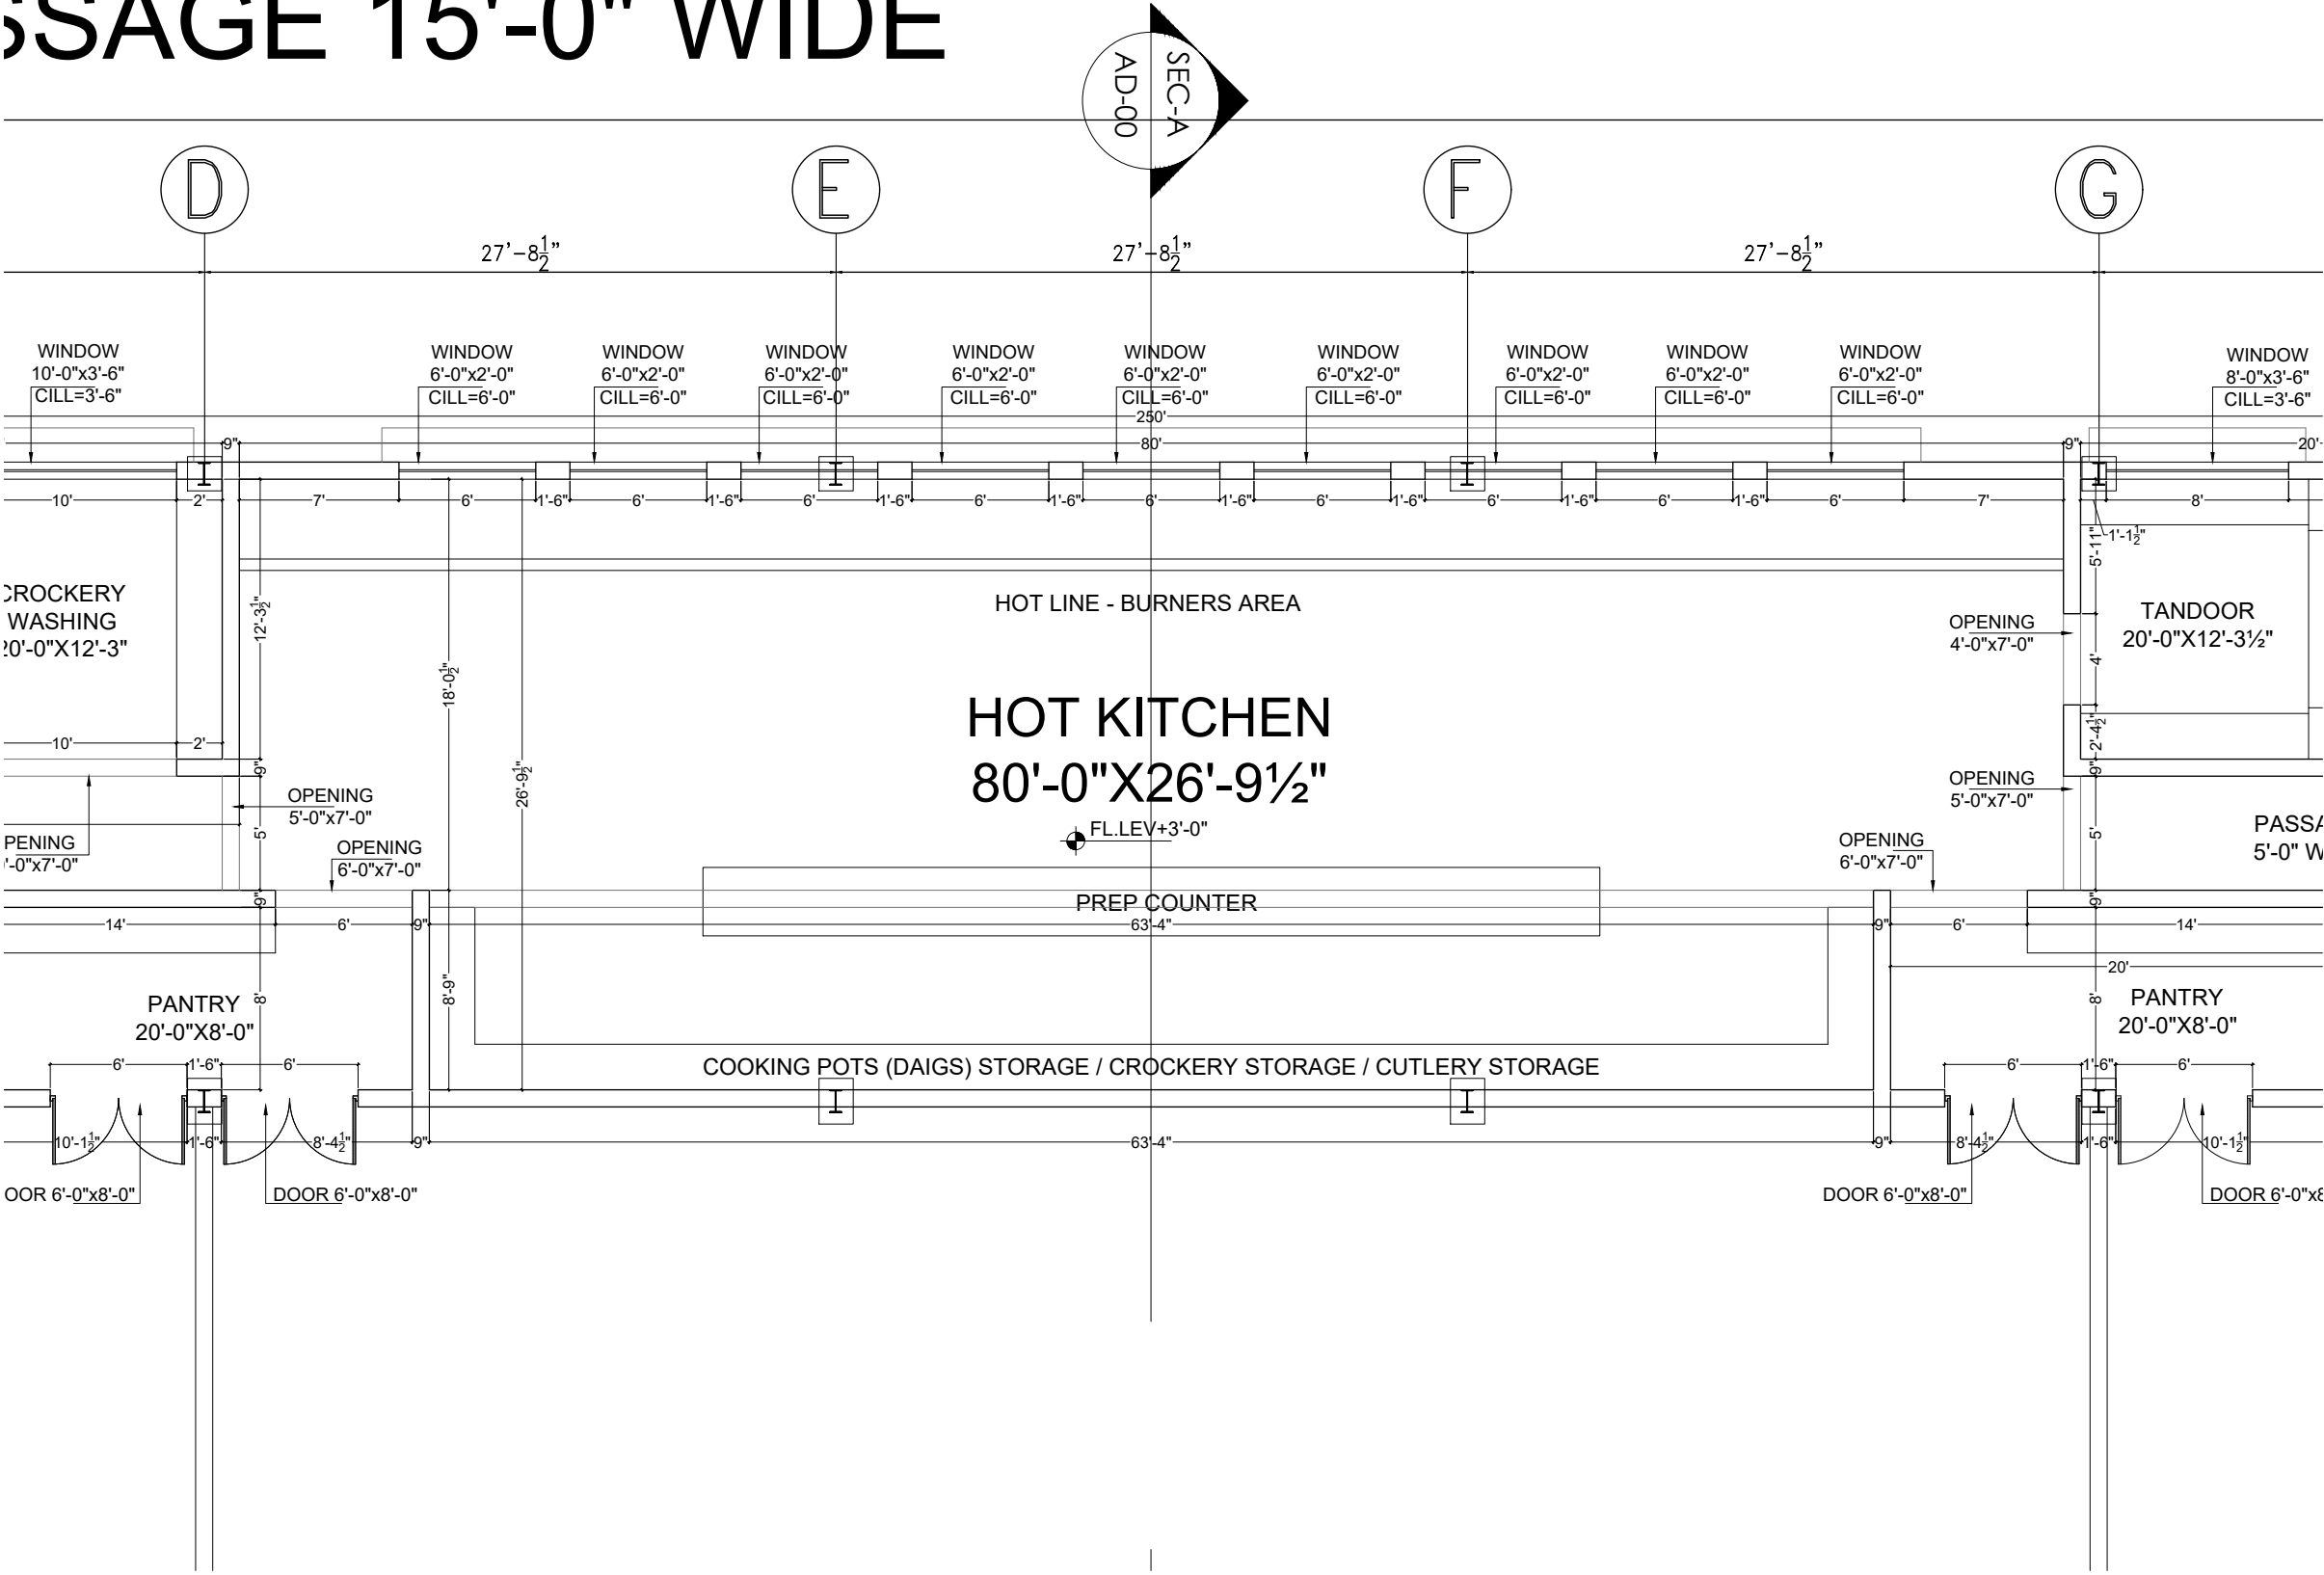


DRAWING NO.: AD-016		PROJECT: EVENT COMPLEX QADIRABAD FOR MR.GUL NAWAZ KHAN		DRAWING TITLE: WORKING DRAWING DRAWING DESCRIPTION: MARQUEE AREA PART-02 WORKING LAYOUT PLAN		SCALE:		KASWA DESIGN SERVICES Consulting Architect & Interior Designers 379 TARIQ BLOCK, NEW GARDEN TOWN, LAHORE 042-35858456, 0336-5858450, kaswadesign@gmail.com	
						DATE: MAY-2026			
NO.		DATE		REVISION		DRAWN BY: BH.		ELECTRICAL CONSULTANT:	
						CHECKED BY: AR.			

 

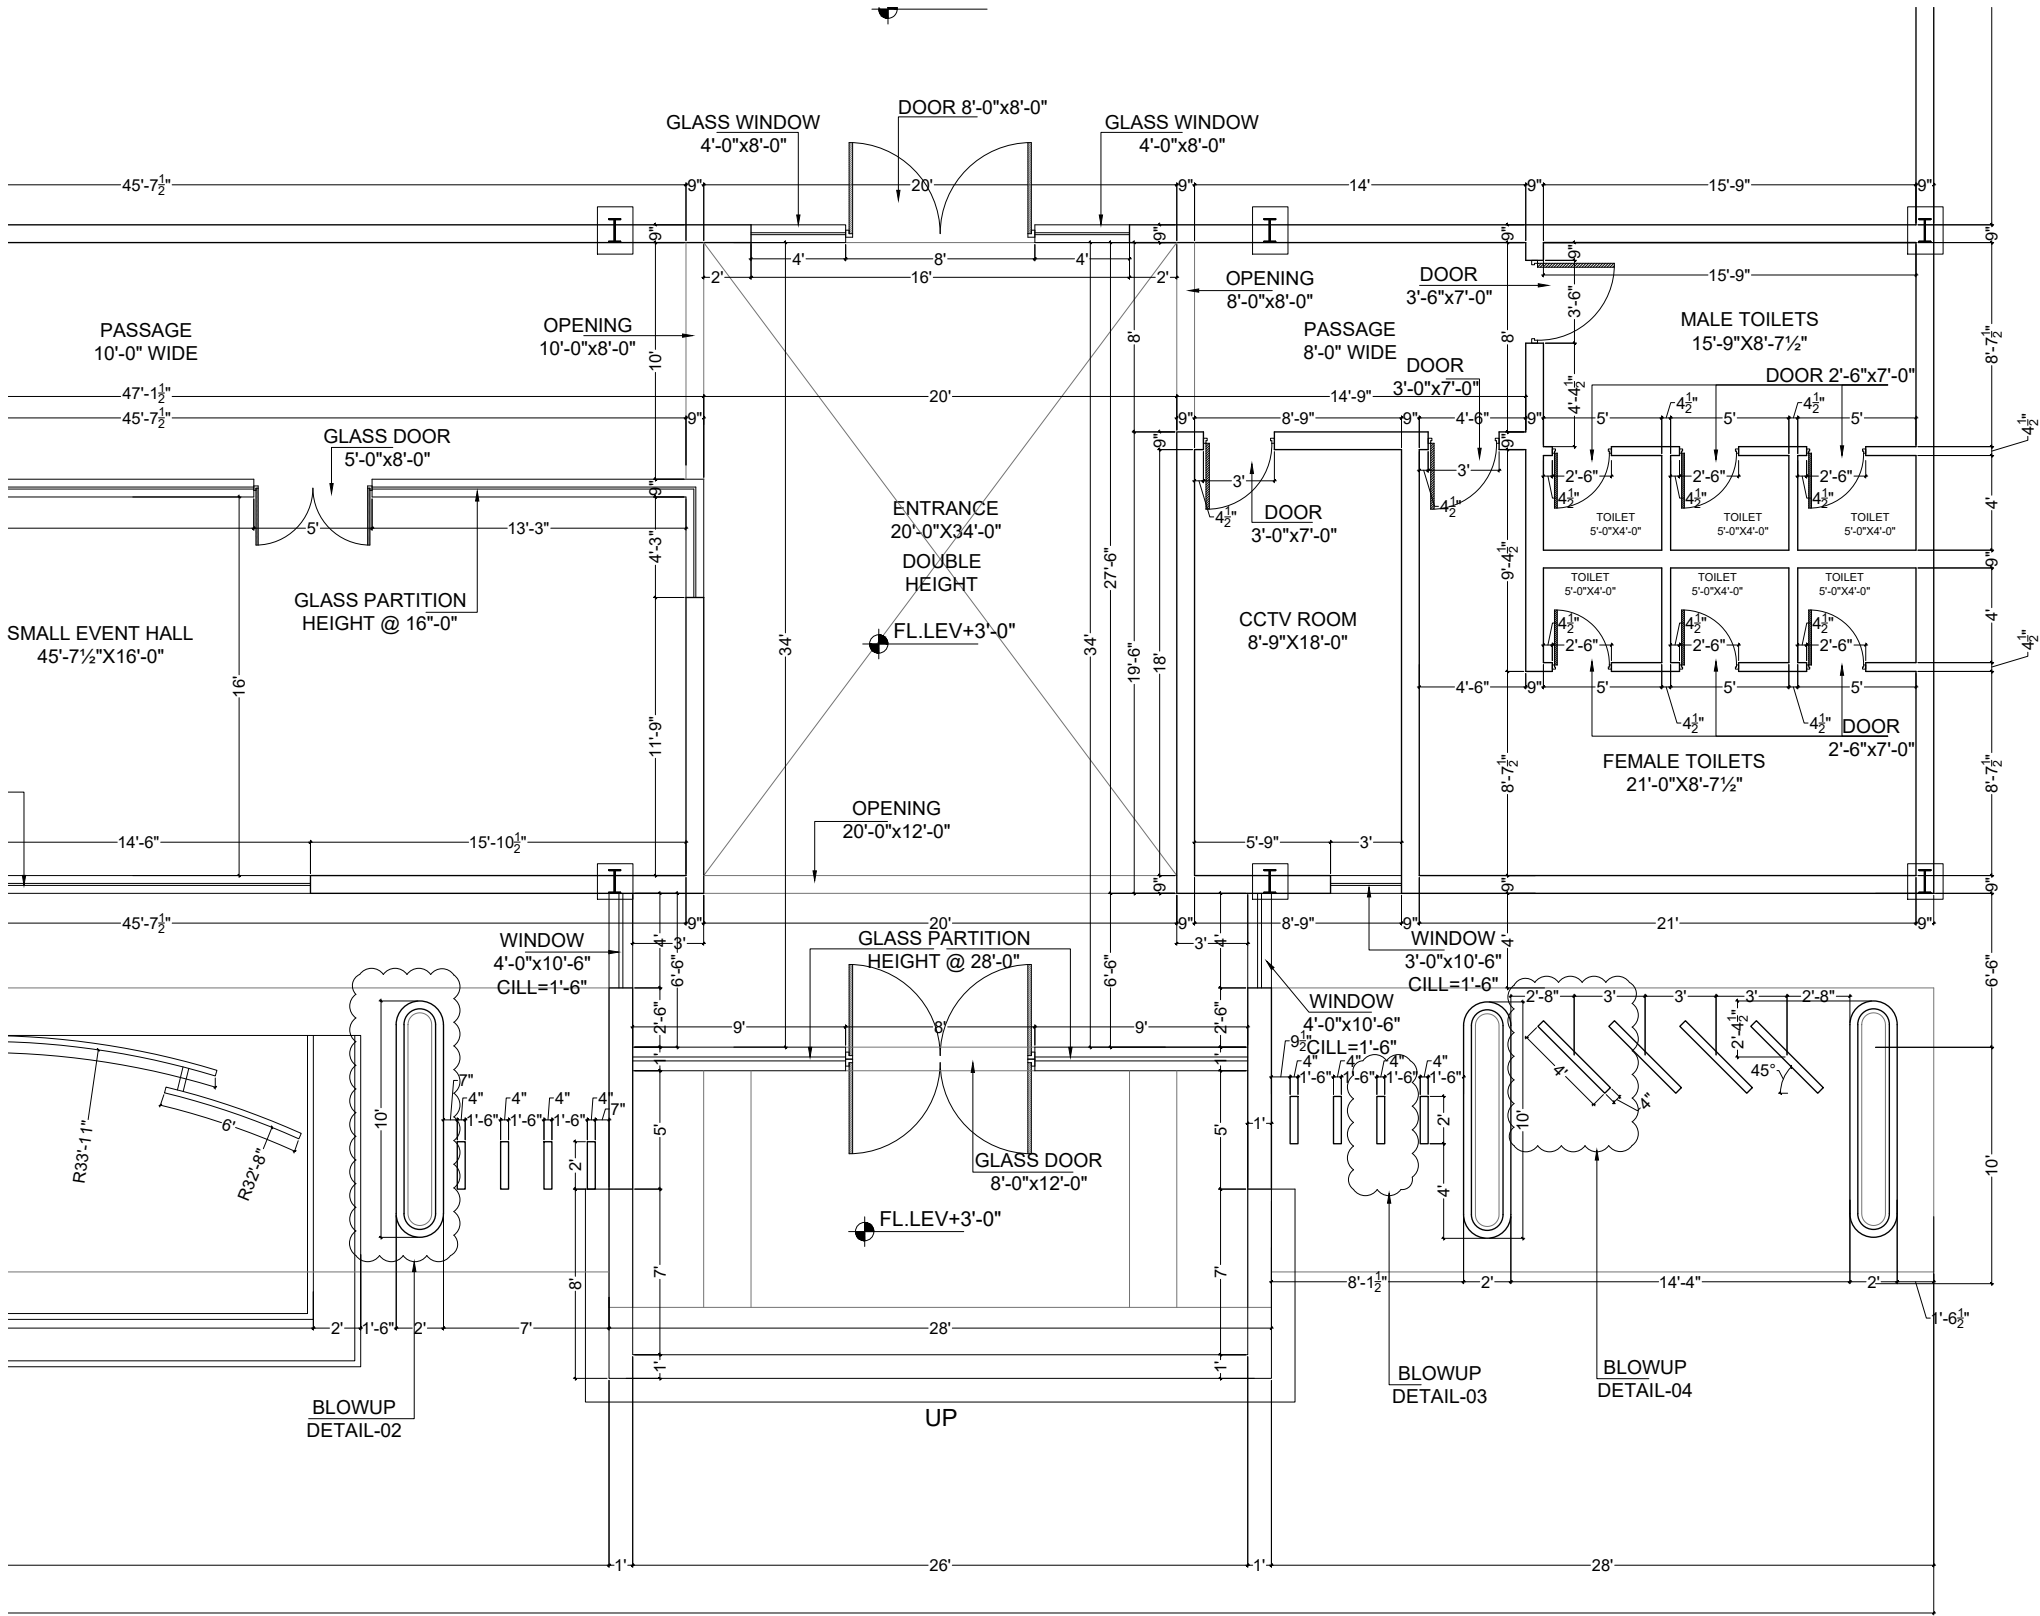

<	
--	--

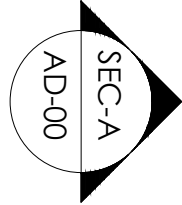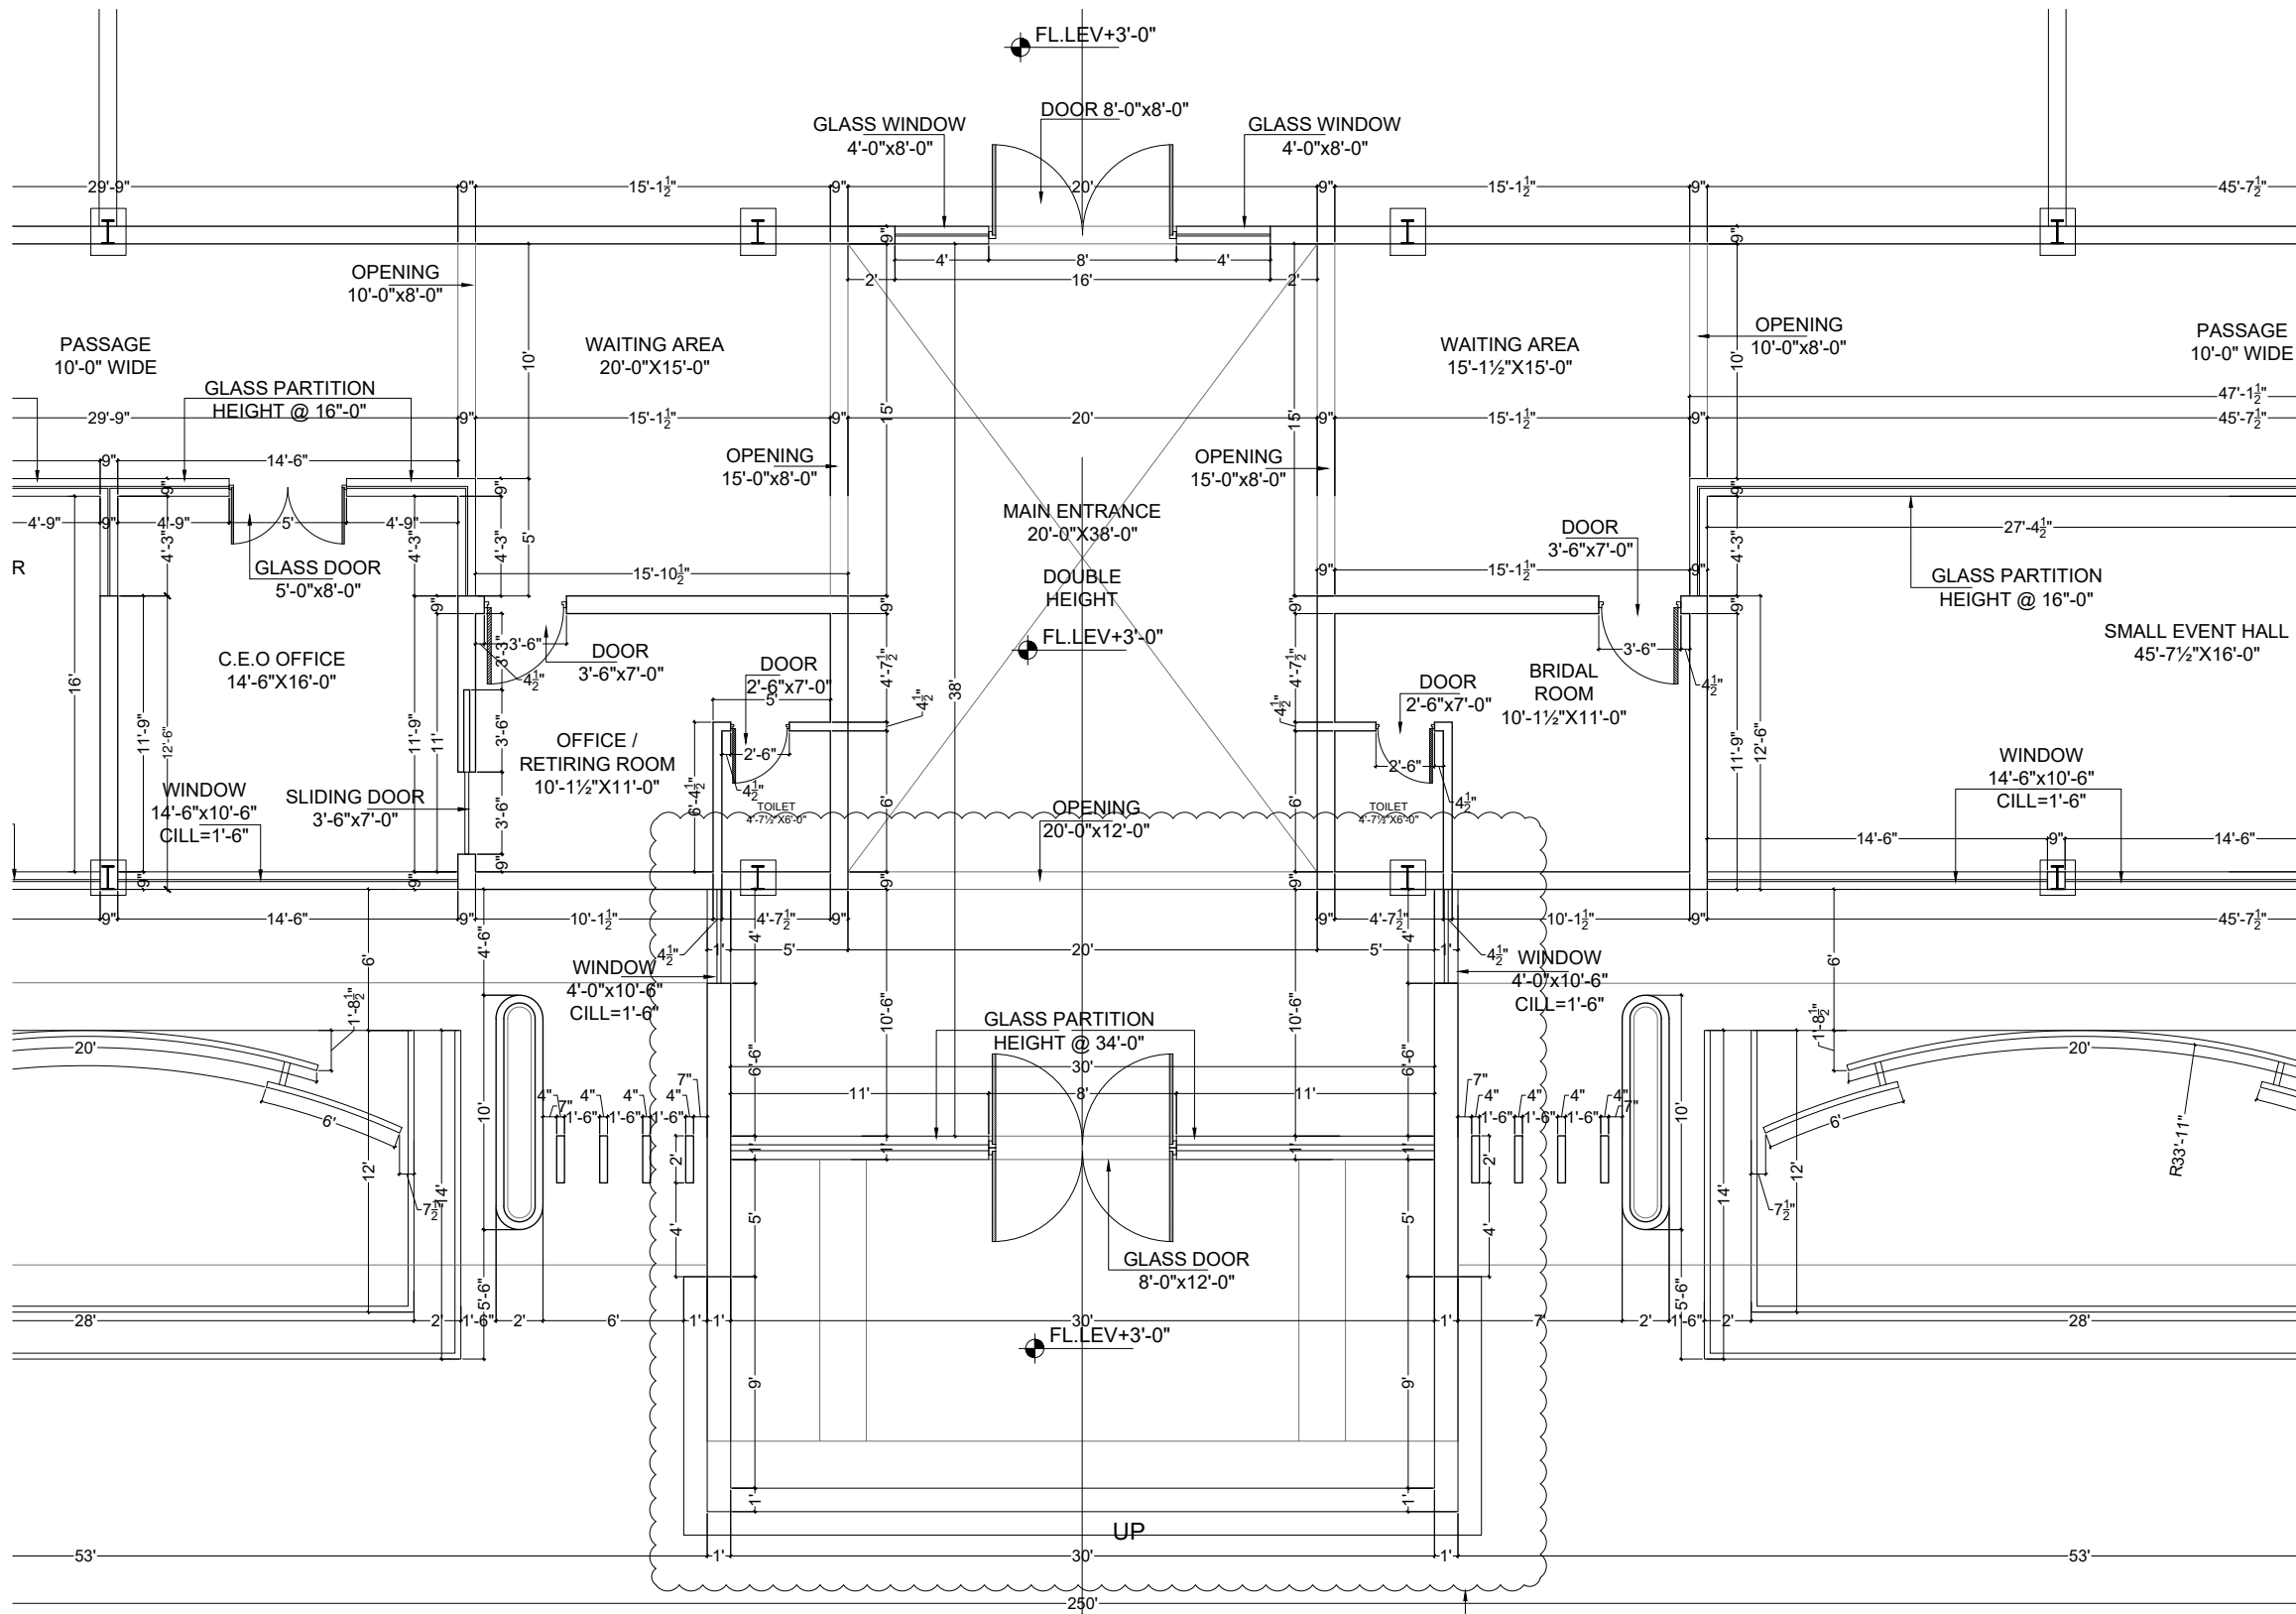

BLOWUP
DETAIL-01

KASWA DESIGN SERVICES
Consulting Architect & Interior Designers
379 TARIQ BLOCK, NEW GARDEN TOWN, LAHORE
042-35858456, 0336-5858450, kaswadesign@gmail.com

ELECTRICAL CONSULTANT:

SCALE:
DATE: MAY-2026
DRAWN BY: BH.
CHECKED BY: AR.

DRAWING TITLE:
WORKING DRAWING
DRAWING DESCRIPTION:
MARQUEE AREA PART-05
WORKING LAYOUT PLAN
LOCATION
QADIRABAD

PROJECT:
EVENT COMPLEX QADIRABAD
FOR
MR.GUL NAWAZ KHAN
PROJECT CODE:
ARCHITECT'S SIGNATURE:

DRAWING NO.: AD-019
NO. DATE REVISION